

ADDENDUM NO. 2

Rochester City School District

Dr. Walter Cooper, School #10

SED Control#: 26-16-00-01-0-037-021

SED DWT Control #: 26-16-00-01-7-999-020

SEI Project No.: 17-3016

January 11th, 2019



GENERAL INSTRUCTIONS:

- Include this Addendum as part of the Construction Documents. This Addendum supplements portions of the original Drawings and Specifications, the intent of which shall remain, except as revised herein.
 - Work described in this Addendum shall be in accordance with the Specifications for like items in remainder of project and complete with all labor and materials included.
-

REVISIONS TO THE PROJECT MANUAL:

SECTION 035416 – HYDRAULIC CEMENT UNDERLAYMENT

- | | |
|----------|--|
| Item 2-1 | REVISE Subparagraph 2.1-A.3 “Ardex America, Ardex SD-P – instant patch self drying, fast setting concrete underlayment patch” to read “Ardex America, Ardex K 15 – rapid setting self-leveling underlayment.” |
| Item 2-2 | REVISE Subparagraph 2.1-A.4 “Cement Binder: ASTM C 150, portland cement, or hydraulic or blended hydraulic cement as defined by ASTM C 219.” to read “Cement Binder: Provide manufacturers approved binder.” |

SECTION 004116 – BID FORM

Item 2-3 **ADD** Subparagraph 1.4-UC-11 as follows:

UC-11	Add the removal and the replacement of existing stone curb on the west side of Virginia Ave. Remove the existing stone curbing for the entire length of the school property and replace with standard City of Rochester stone curbing. Include removing and replacing a 2 foot wide strip of the asphalt road pavement. All new work shall meet the City of Rochester construction details and specifications	\$	LF
-------	---	----	----

SECTION 004322 – UNIT PRICES

Item 2-4 **ADD** Subparagraph 3.1-UC-11 as follows:

"UC-11 Add the removal and the replacement of existing stone curb on the west side of Virginia Ave. Remove the existing stone curbing for the entire length of the school property and replace with standard City of Rochester stone curbing. Include removing and replacing a 2 foot wide strip of the asphalt road pavement. All new work shall meet the City of Rochester construction details and specifications (Per LF)"

SECTION 087100 – DOOR HARDWARE

Item 2-5 **DELETE** door C203B from Article 3.4, hardware group number 63.
Item 2-6 **DELETE** hardware group number 80 from Article 3.4 in its entirety.
Item 2-7 **ADD** doors C201B and C203B to Article 3.4, hardware group number 44.
Item 2-8 **ADD** the following hardware to Article 3.4, hardware group number 55:
"1 EA OVERHEAD STOP 100S 630 GLY"
Item 2-9 **ADD** the following hardware to Article 3.4, hardware group number 76:
"1 EA OVERHEAD STOP 100S 630 GLY"

SECTION 088770 – GLAZING FILMS

Item 2-10 **DELETE** Article 2.2 safety and security film in its entirety.
Item 2-11 **DELETE** Article 2.3 privacy film in its entirety.

SECTION 122413 – ROLLER WINDOW SHADES

Item 2-12 **DELETE** Subparagraph 2.2-F.1.b, light-blocking fabric in its entirety.

REVISIONS TO THE DRAWINGS:

DRAWING NO. S2001 – PARTIAL FOUNDATION PLAN

Item 2-13 **REVISE** note “T/WALL EL. -4'-6”” near column A4 to read “T/WALL EL. -2'-0”.”

DRAWING NO. A1004 – DEMOLITION PLAN – SECOND FLOOR AREA B

Item 2-14 **REVISE** note “ALTERNATE NO. 01” to read “ALTERNATE NO. 02” on Plan 1 SECOND FLOOR DEMOLITION PLAN – AREA B.

DRAWING NO. A1102 – FLOOR PLAN – FIRST FLOOR AREA A

Item 2-15 **REVISE** Plan 1 FIRST FLOOR PLAN – AREA A as detailed on AD2-A3 PARTIAL FIRST FLOOR PLAN AREA A (dated 01/11/19).

DRAWING NO. A1104 – FLOOR PLAN – SECOND FLOOR AREA A

Item 2-16 **REVISE** Plan 1 SECOND FLOOR PLAN – AREA A as detailed on AD2-A1 PARTIAL SECOND FLOOR PLAN AREA A (dated 01/11/19).

Item 2-17 **REVISE** Plan 1 SECOND FLOOR PLAN – AREA as detailed on AD2-A4 PARTIAL SECOND FLOOR PLAN AREA A (dated 01/11/19).

DRAWING NO. A1134 – REFLECTED CEILING PLAN – SECOND FLOOR AREA A

Item 2-18 **REVISE** Plan 1 PARTIAL SECOND FLOOR REFLECTED CEILING PLAN – AREA A as detailed on AD2-A2 PARTIAL SECOND FLOOR RCP AREA A (dated 01/11/19).

DRAWING NO. A1160 – ROOF PLAN – AREA A

Item 2-19 **REVISE** general note number 4 “ROOFS ON 1/A1160 ARE NEW CONSTRUCTION, REFER TO TYPICAL EPDM ON METAL DECK ROOF SYSTEM ON A0001” to read as “ALL ROOFS SHOWN ON THIS DRAWING ARE BASE BID. THE CONTRACTOR SHALL REFER TO DRAWING A0001 FOR THE TYPICAL EPDM ROOF ASSEMBLY DETAIL.”

Item 2-20 **DELETE** general note number 5 “ROOFS ON 1/A1161 ARE EXISTING TO REMAIN, THE NEW ROOF SHOULD MATCH THE ADJACENT EXISTING ROOF ASSEMBLY” in its entirety.

DRAWING NO. A1161 – ROOF PLAN – AREA B

Item 2-21 **REVISE** general note number 4 “ROOFS ON 1/A1160 ARE NEW CONSTRUCTION, REFER TO TYPICAL EPDM ON METAL DECK ROOF SYSTEM ON A0001” to read as “THE CONTRACTOR SHALL FIELD VERIFY THE EXISTING ROOF ASSEMBLY AS SHOWN ON THIS DRAWING. ANY ROOF PATCHING THAT IS THE RESULT OF SPECIFIED PLUMBING SCOPE, SPECIFIED MECHANICAL SCOPE, SPECIFIED ELECTRICAL SCOPE, CHIMNEY

DEMOLITION, ETC. SHALL BE PROVIDED BY THE GENERAL CONTRACTOR AND SHALL MATCH THE EXISTING ADJACENT ROOF ASSEMBLY UNLESS OTHERWISE NOTED."

- Item 2-22 **DELETE** general note number 5 "ROOFS ON 1/A1161 ARE EXISTING TO REMAIN, THE NEW ROOF SHOULD MATCH THE ADJACENT EXISTING ROOF ASSEMBLY" in its entirety.

DRAWING NO. A1230 – DOOR SCHEDULE AND FRAME TYPES

- Item 2-23 **DELETE** drawing A1230 DOOR SCHEDULE AND FRAME TYPES (dated 12/13/2018) in its entirety. **ADD** drawing A1230 DOOR SCHEDULE AND FRAME TYPES (revision date 01/11/19) in its entirety.

DRAWING NO. A1610 – DETAILS

- Item 2-24 **DELETE** the following note from drawing 2/A1610:
"EXTERIOR CAN LIGHT, REFER TO ELECTRICAL DWGS"
- Item 2-25 **DELETE** the following note from drawing 2/A1610:
"ELECTRICAL CONDUIT, COORDINATE w/ NEW BENCHES"

DRAWING NO. A1700 – ROOM FINISH SCHEDULE AND PATTERN DETAILS

- Item 2-26 **ADD** the following comment to the room finish schedule, room # 120:
"DO NOT PROVIDE FLOORING IN OR UNDER THE FREEZER AND COOLER. FLOORING IN THE FREEZER AND COOLER IS BY OTHERS, REFER TO DRAWING QF1401 FOR ADDITIONAL INFORMATION"

DRAWING NO. A1800 – FURNITURE PLAN – FIRST FLOOR AREA A & LOWER LEVEL

- Item 2-27 **DELETE** drawing A1800 FURNITURE PLAN – FIRST FLOOR AREA A & LOWER LEVEL (dated 12/13/2018) in its entirety. **ADD** drawing A1800 FURNITURE PLAN – FIRST FLOOR AREA A & LOWER LEVEL (revision date 01/11/19) in its entirety.

DRAWING NO. A1801 – FURNITURE PLAN – FIRST FLOOR AREA B

- Item 2-28 **DELETE** drawing A1801 FURNITURE PLAN – FIRST FLOOR AREA B (dated 12/13/2018) in its entirety. **ADD** drawing A1801 FURNITURE PLAN – FIRST FLOOR AREA B (revision date 01/11/19) in its entirety.

DRAWING NO. A1802 – FURNITURE PLAN – SECOND FLOOR AREA A

- Item 2-29 **DELETE** drawing A1802 FURNITURE PLAN – SECOND FLOOR AREA A (dated 12/13/2018) in its entirety. **ADD** drawing A1802 FURNITURE PLAN – SECOND FLOOR AREA A (revision date 01/11/19) in its entirety.

DRAWING NO. A1803 – FURNITURE PLAN – SECOND FLOOR AREA B

- Item 2-30 **DELETE** drawing A1803 FURNITURE PLAN – SECOND FLOOR AREA B (dated 12/13/2018) in its entirety. **ADD** drawing A1803 FURNITURE PLAN – SECOND FLOOR AREA B (revision date 01/11/19) in its entirety.

DRAWING NO. A1900 – SIGNAGE PLAN – LOWER LEVEL

- Item 2-31 **DELETE** drawing A1900 SIGNAGE PLAN – LOWER LEVEL (dated 12/13/2018) in its entirety. **ADD** drawing A1900 SIGNAGE PLAN – LOWER LEVEL (revision date 01/11/19) in its entirety.

DRAWING NO. A1901 – SIGNAGE PLAN – FIRST AND SECOND FLOOR

- Item 2-32 **DELETE** drawing A1901 SIGNAGE PLAN – FIRST AND SECOND FLOOR (dated 12/13/2018) in its entirety. **ADD** drawing A1901 SIGNAGE PLAN – FIRST AND SECOND FLOOR (revision date 01/11/19) in its entirety.

DRAWING NO. A1902 – SIGNAGE SCHEDULE

- Item 2-33 **DELETE** drawing A1902 SIGNAGE SCHEDULE (dated 12/13/2018) in its entirety. **ADD** drawing A1902 SIGNAGE SCHEDULE (revision date 01/11/19) in its entirety.

DRAWING NO. H1204 – PARTIAL SECOND FLOOR PLAN - HVAC

- Item 2-34 **REVISE** 70x48 outside air intake ductwork to include motorized damper at roof penetration per AD2-H2 (dated 01/11/19).
- Item 2-35 **REVISE** 12x10(L) supply air ductwork to include smoke damper and duct smoke detector at corridor smoke door crossing per AD2-H3 (dated 01/11/19).

DRAWING NO. H1301 – PARTIAL LOWER LEVEL PLAN – HVAC PIPING

- Item 2-36 **REVISE** boiler piping size to 3" per AD2-H4 (dated 01/11/19).

DRAWING NO. H1401 – ENLARGED FLOOR PLANS - HVAC

- Item 2-37 **REVISE** note number seven per AD2-H1 (dated 01/11/19).

DRAWING NO. H1600 – SCHEDULES - HVAC

- Item 2-38 **REVISE** cabinet unit heater schedule to remove duplicates per drawing AD2-H5 (dated 01/11/19).
- Item 2-39 **REVISE** pump schedule per drawing AD2-H6 (dated 01/11/19).

DRAWING NO. E1204 – PARTIAL SECOND FLOOR PLAN - POWER AND SS - AREA A

Item 2-40 **REVISE** magnetic door holders, rooftop receptacle, smoke damper, duct smoke detector, and remote test station per AD2-E1 (dated 01/11/19).

DRAWING NO. E1205 – PARTIAL SECOND FLOOR PLAN - POWER AND SS - AREA B

Item 2-41 **REVISE** magnetic door holders per AD2-E2 (dated 01/11/19).

DRAWING NO. E1304 – PARTIAL SECOND FLOOR PLAN - LIGHTING - AREA A

Item 2-1 **REVISE** lighting and light switches per AD2-E3 (dated 01/11/19).


DRAWING NO. E1305 – PARTIAL SECOND FLOOR PLAN - LIGHTING - AREA B

Item 2-2 **REVISE** lighting and light switches per AD2-E4 (dated 01/11/19).

ATTACHMENTS:

AD2-A1	PARTIAL SECOND FLOOR PLAN AREA A (dated 01/11/19)
AD2-A2	PARTIAL SECOND FLOOR RCP AREA A (dated 01/11/19)
AD2-A3	PARTIAL FIRST FLOOR PLAN (dated 01/11/19)
AD2-A4	PARTIAL SECOND FLOOR PLAN (dated 01/11/19)
AD2-H1	PARTIAL LOWER LEVEL FLOOR PLAN – HVAC (dated 01/11/19)
AD2-H2	PARTIAL SECOND FLOOR PLAN - HVAC (dated 01/11/19)
AD2-H3	PARTIAL SECOND FLOOR PLAN - HVAC (dated 01/11/19)
AD2-H4	PARTIAL LOWER LEVEL FLOOR PLAN - HVAC PIPING (dated 01/11/19)
AD2-H5	CABINET UNIT HEATER SCHEDULE - HVAC (dated 01/11/19)
AD2-H6	PUMP SCHEDULE - HVAC (dated 01/11/19)
AD2-E1	PARTIAL SECOND FLOOR PLAN - POWER AND SS - AREA A (dated 01/11/19)
AD2-E2	PARTIAL SECOND FLOOR PLAN - POWER AND SS - AREA B (dated 01/11/19)
AD2-E3	PARTIAL SECOND FLOOR PLAN - LIGHTING - AREA A (dated 01/11/19)
AD2-E4	PARTIAL SECOND FLOOR PLAN - LIGHTING - AREA B (dated 01/11/19)
A1230	DOOR SCHEDULE AND FRAME TYPES (revision date 01/11/19)
A1800	FURNITURE PLAN – FIRST FLOOR AREA A & LOWER LEVEL (revision date 01/11/19)
A1801	FURNITURE PLAN – FIRST FLOOR AREA B (revision date 01/11/19)
A1802	FURNITURE PLAN – SECOND FLOOR AREA A (revision date 01/11/19)
A1803	FURNITURE PLAN – SECOND FLOOR AREA B (revision date 01/11/19)
A1900	SIGNAGE PLAN – LOWER LEVEL (revision date 01/11/19)
A1901	SIGNAGE PLAN – FIRST AND SECOND FLOOR (revision date 01/11/19)
A1902	SIGNAGE SCHEDULE (revision date 01/11/19)
	Pre-Bid RFI log (dated 01/11/19)

End of Addendum No. 2

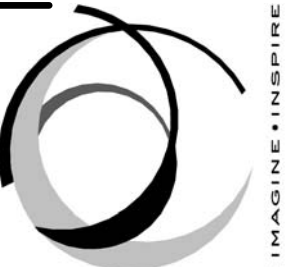

SEI
design group

585.442.7010 • 224 Mill St. • Rochester, NY 14614
518.435.2467 • 187 Wolf Rd., Suite 304 • Albany, NY 12205
607.304.4550 • 2 Court St., Suite 404 • Binghamton, NY 13901

**ROCHESTER CITY
SCHOOL DISTRICT**

**DR. WALTER
COOPER, SCHOOL
#10**

SCHOOL 10
353 CONGRESS AVE.
ROCHESTER, NEW YORK 14619


SED Control No. 26-16-00-01-0-037-021

Date	01/11/19	SEI Project No.	17-3016
Revisions			
1	01/11/19	ADDENDUM	


**PARTIAL SECOND FLOOR PLAN
AREA A**

AD2 - A1

Reference DWG. 1/A1104

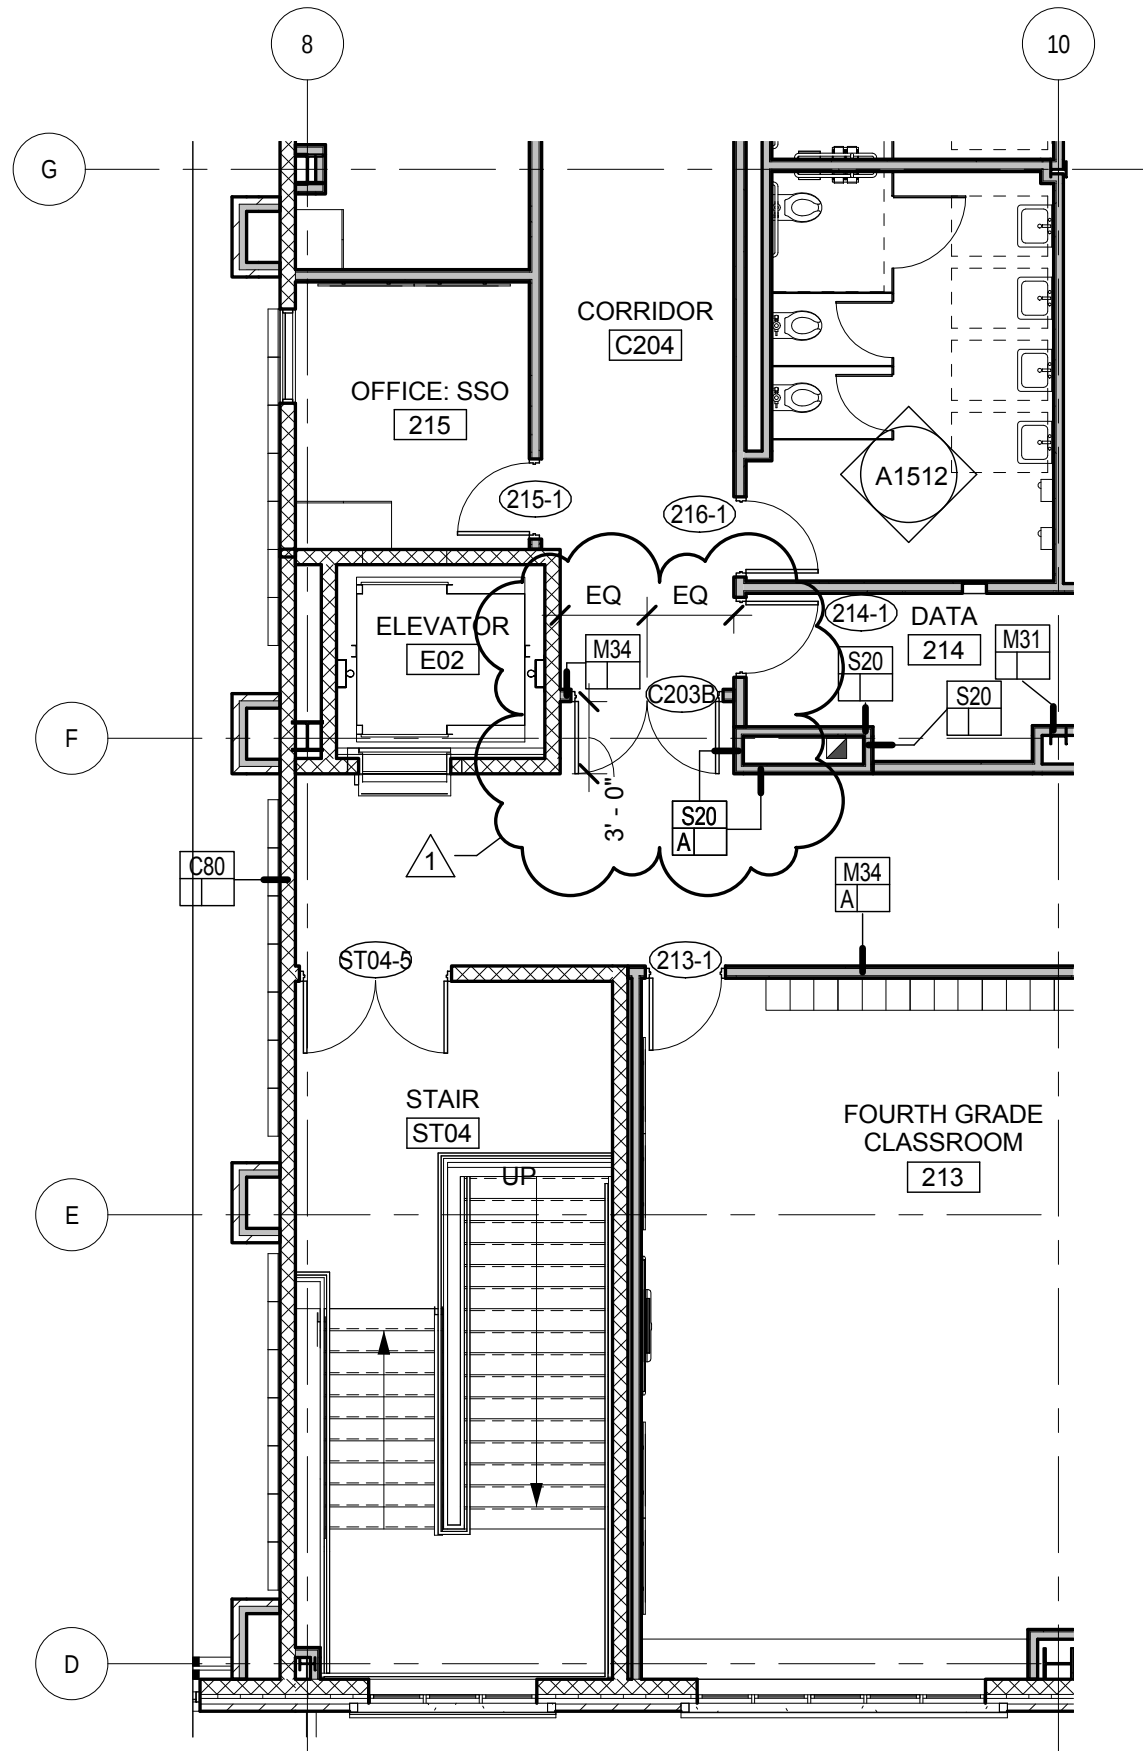


2 PARTIAL SECOND FLOOR PLAN
1/8" = 1'-0"

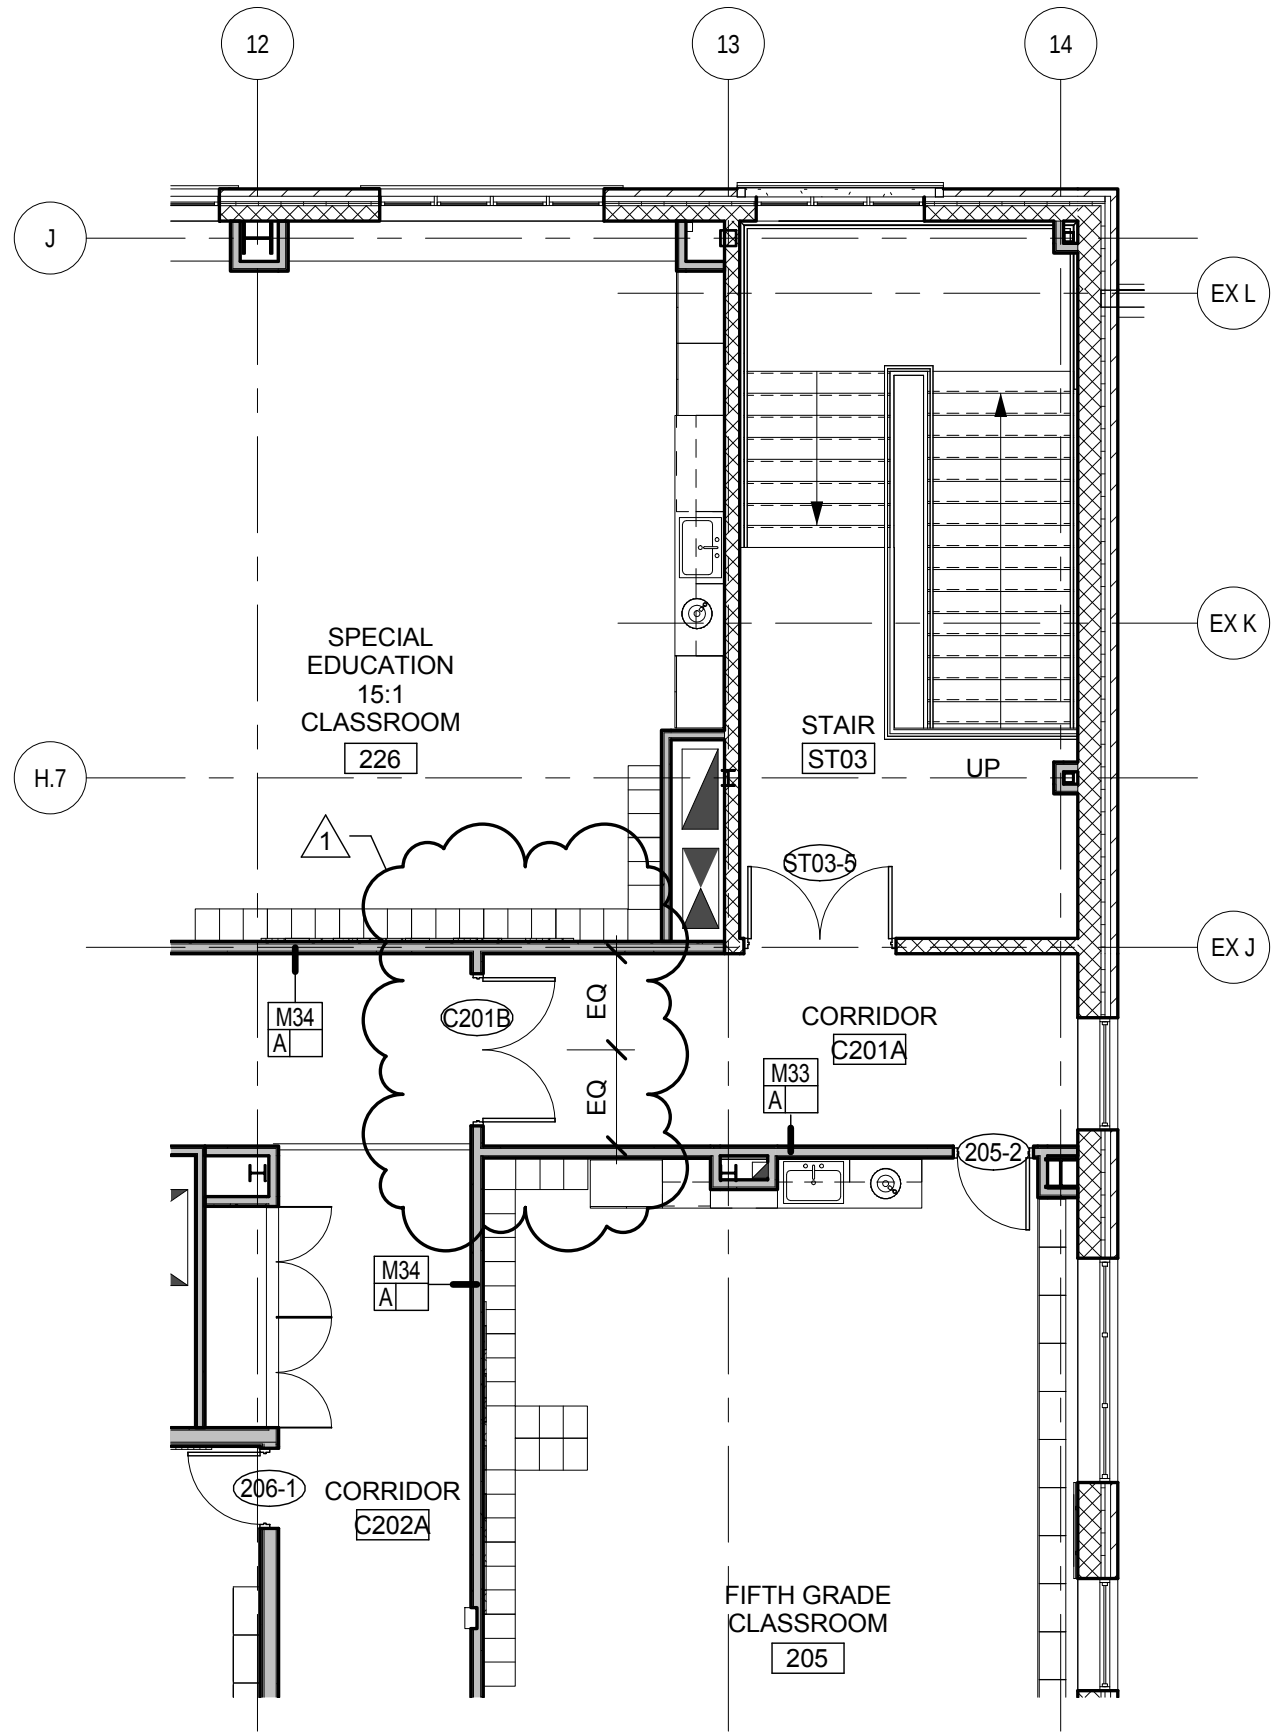


1 PARTIAL SECOND FLOOR PLAN
1/8" = 1'-0"

GENERAL NOTE:
COORDINATE THE LOCATION OF EXIT SIGNS, AREA OF REFUGE SIGNS,
DOOR HOLD OPENS AND OTHER ELECTRICAL DEVICES WITH THE REVISED
LOCATION OF DOORS C201B AND C203B

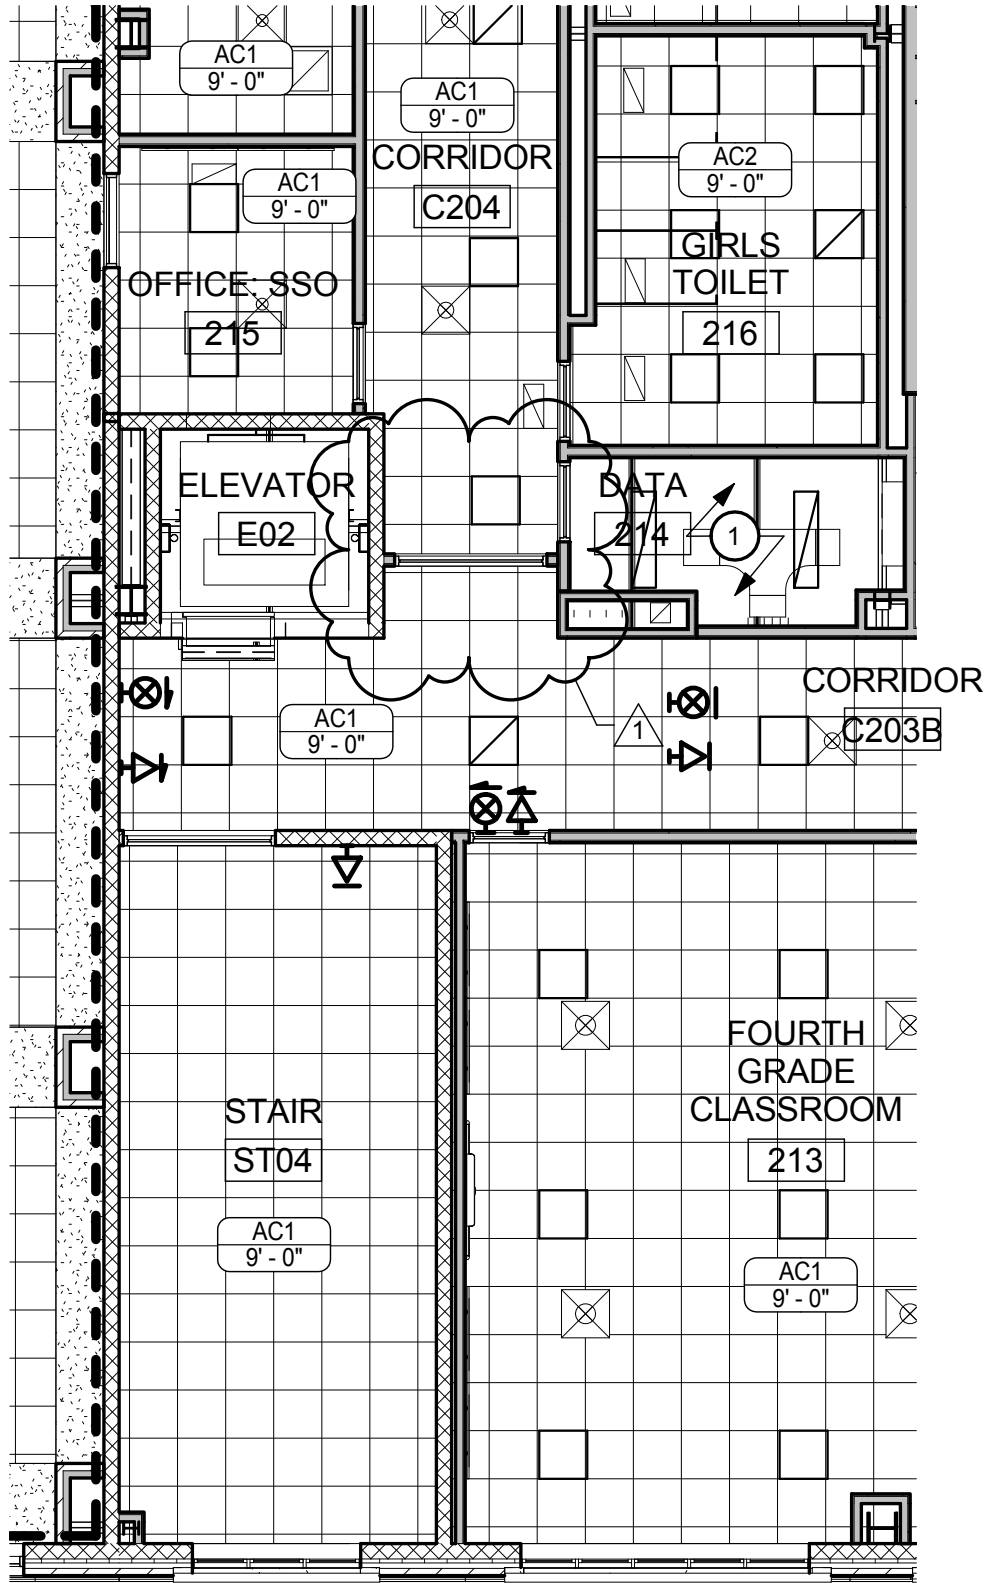

2 PARTIAL SECOND FLOOR RCP
1/8" = 1'-0"

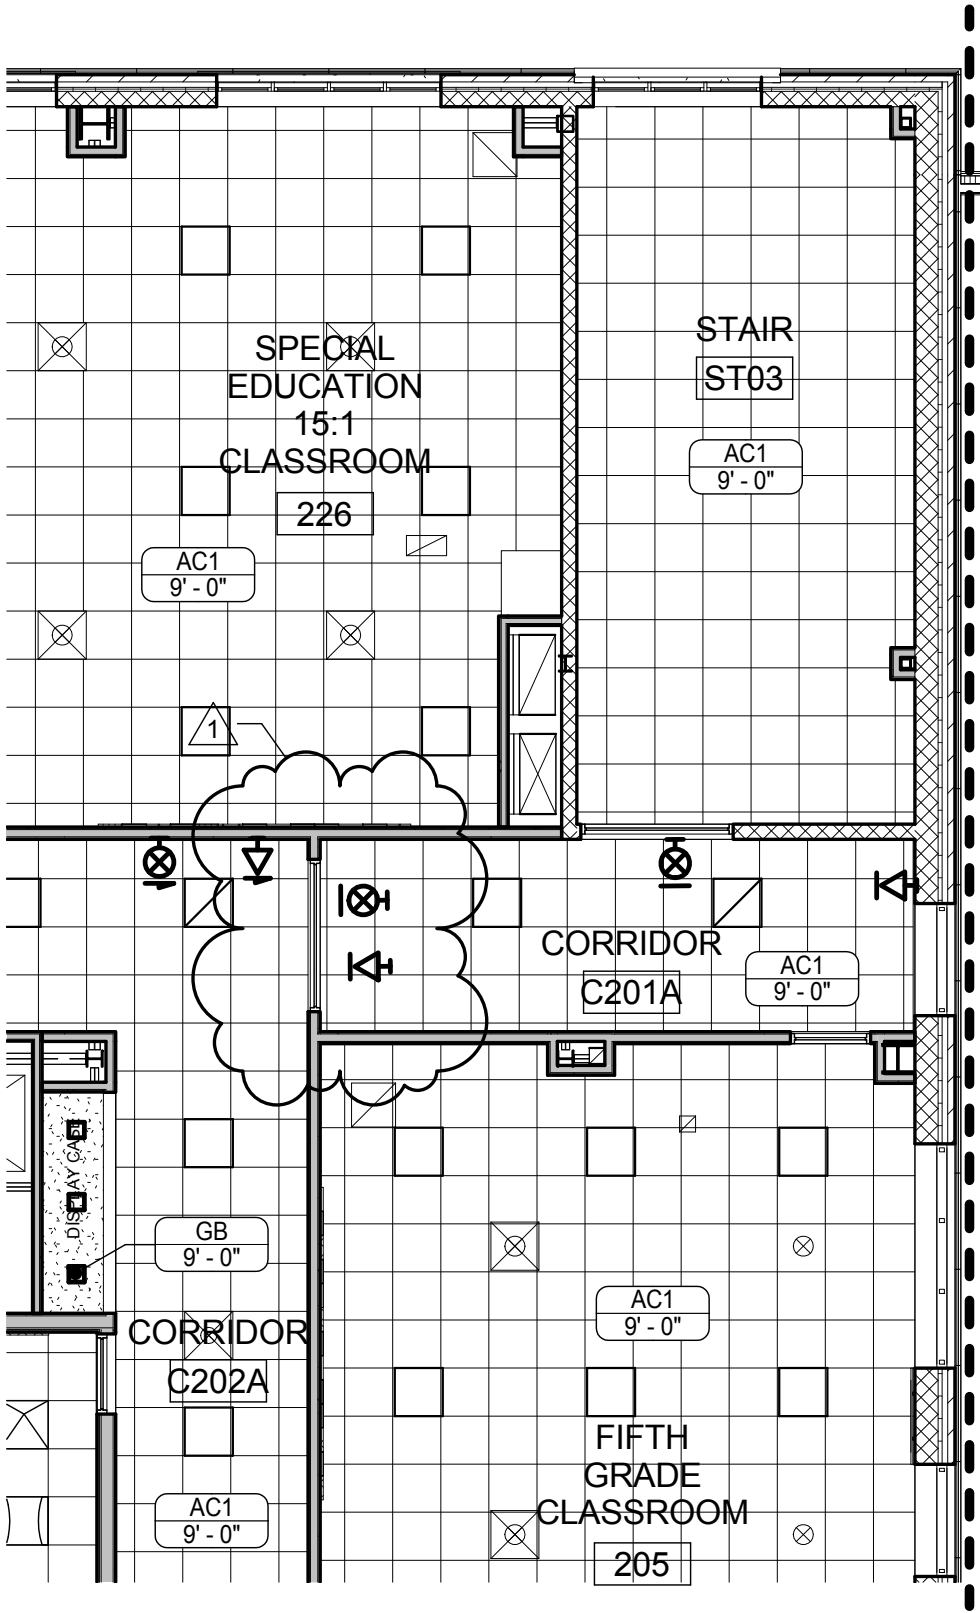

1 PARTIAL SECOND FLOOR RCP
1/8" = 1'-0"

**ROCHESTER CITY
SCHOOL DISTRICT**

**DR. WALTER
COOPER, SCHOOL
#10**

SCHOOL 10
353 CONGRESS AVE.
ROCHESTER, NEW YORK 14619


SED Control No. 26-16-00-01-0-037-021

Date	01/11/19	SEI Project No.	17-3016
Revisions			
1	01/11/19	ADDENDUM	

**PARTIAL FIRST FLOOR PLAN
AREA A**

AD2 - A3


Reference DWG. 1/A1102

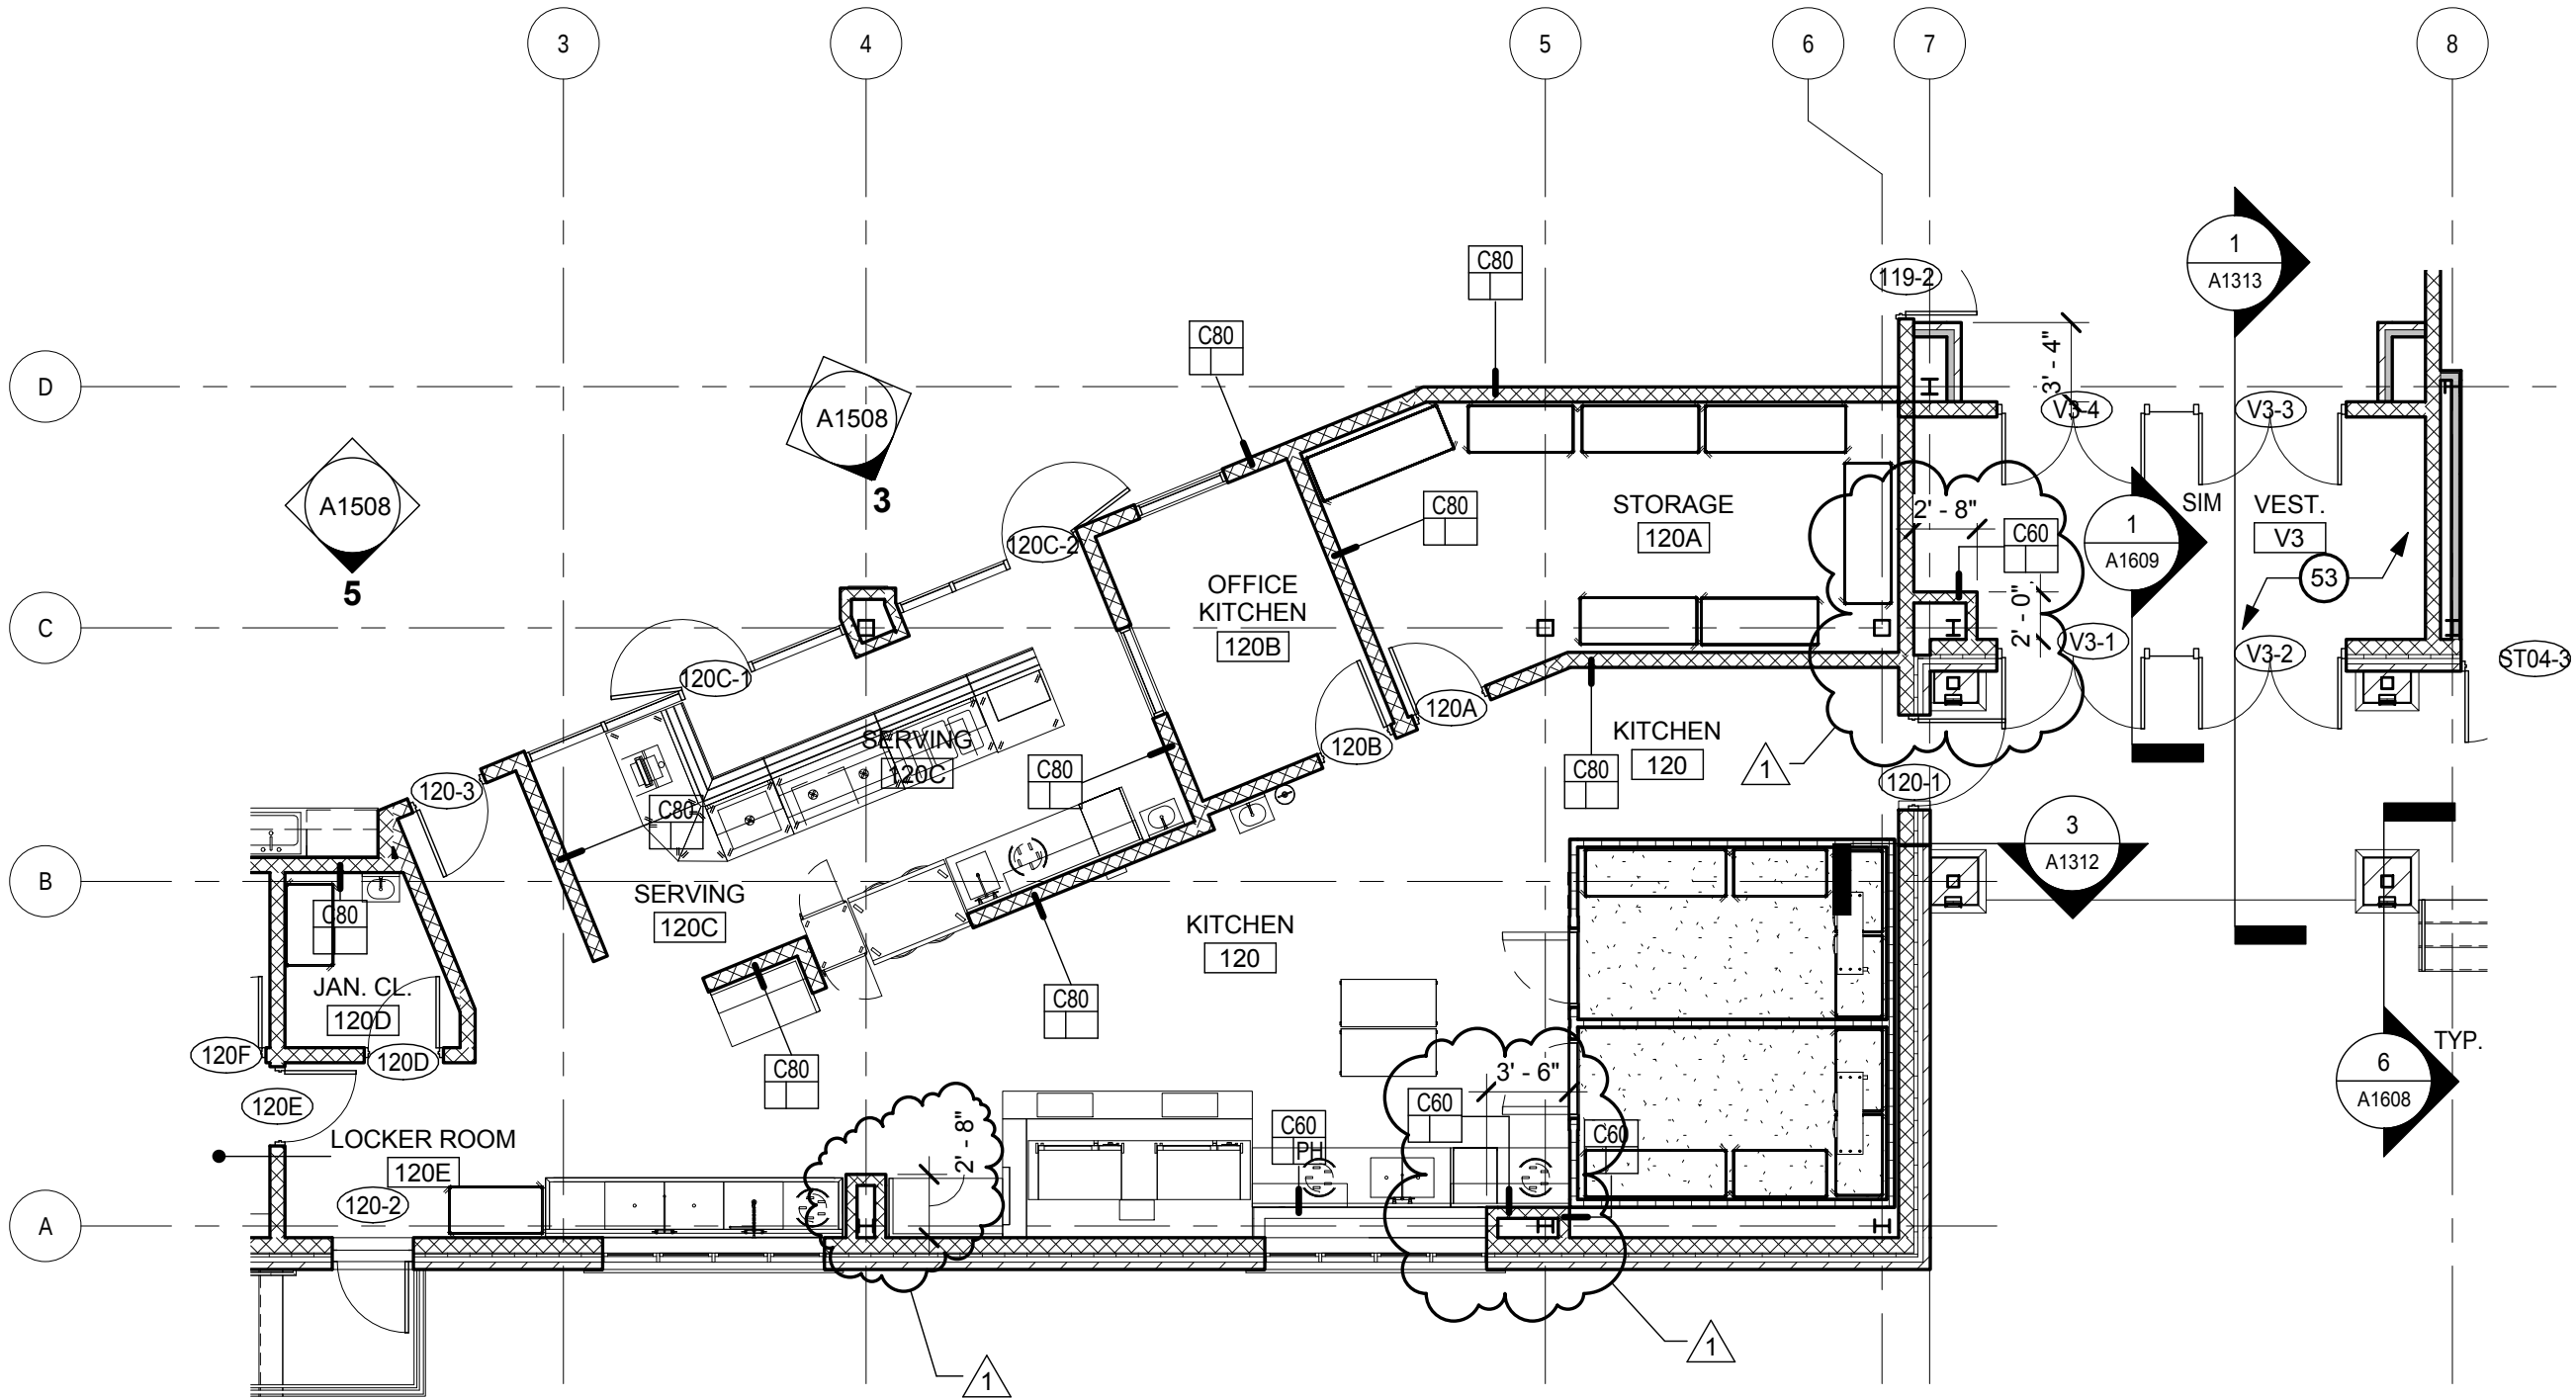

1 FIRST FLOOR PLAN
1/8" = 1'-0"

AD2-H1 DRAWING NOTES

- 5
- PROVIDE 8" FLUE DAMPER KIT MODEL 100141561 AS MANUFACTURED BY LOCHINVAR AT FLUE OUTLET. PROVIDE INLINE DRAIN ABOVE DAMPER.
- 6
- INSTALL BOILER COMMON VENT PIPING IN ACCORDANCE WITH MANUFACTURER RECOMMENDATIONS. PROVIDE STAINLESS STEEL PIPING MODEL FasNSeal AS MANUFACTURED BY PROTECH SYSTEMS OR EQUIVALENT STAINLESS STEEL VENT APPROVED BY BOILER MANUFACTURER. PITCH FLUE AIR DUCTWORK DOWN TOWARDS BOILERS MINIMUM 1/4" PER FOOT.
- 7
- ROUTE 10" DIAMETER FLUE PIPING UP THROUGH ROOF. PROVIDE DRAIN CONNECTION AT BOTTOM OF T CONNECTION. PROVIDE DRAIN PIPING TO CONDENSATE NEUTRALIZER.
- 8
- ROUTE 8" COMBUSTION AIR PIPING UP THROUGH FLOOR ABOVE AND THROUGH ROOF. PROVIDE GOOSENECK TERMINATION. REFER TO DETAIL.
- 11
- PROVIDE 4" HIGH CONCRETE EQUIPMENT PAD. EQUIPMENT PAD SHALL EXTEND 6" BEYOND THE FOOTPRINT OF THE UNIT ON ALL SIDES.

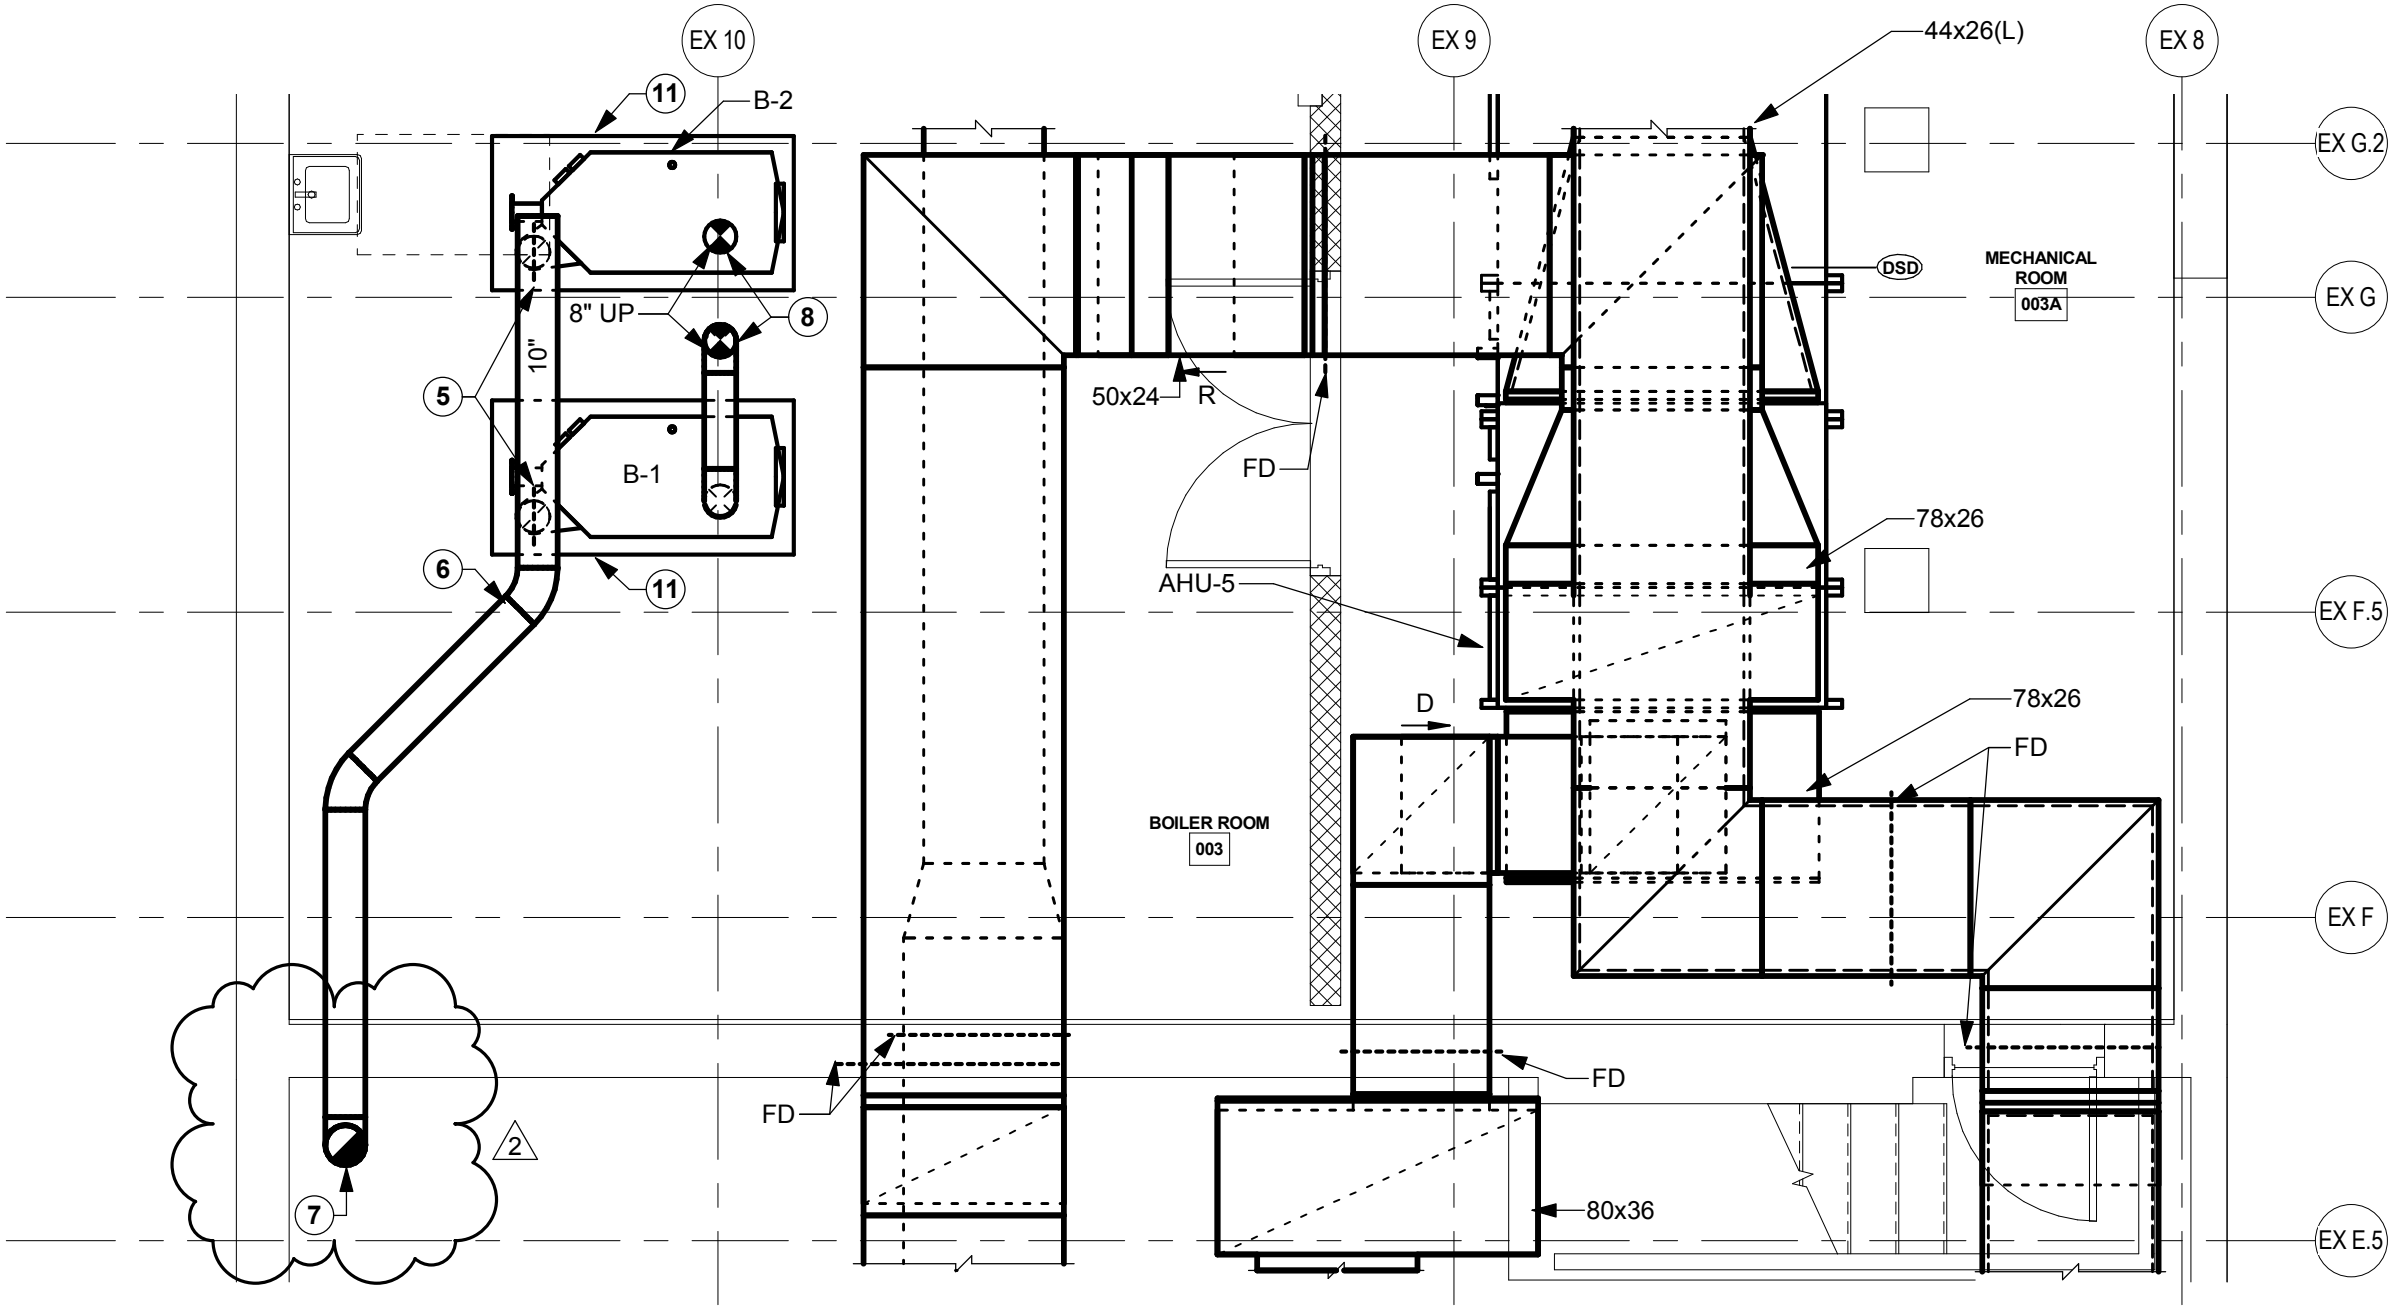

1 PARTIAL LOWER LEVEL PLAN - HVAC DUCTWORK
1/4" = 1'-0"



SEI
design group

585.442.7010 • 224 Mill St. • Rochester, NY 14614
518.435.2467 • 187 Wolf Rd., Suite 304 • Albany, NY 12205
607.304.4550 • 2 Court St., Suite 404 • Binghamton, NY 13901

ROCHESTER CITY
SCHOOL DISTRICT

DR. WALTER COOPER

SCHOOL 10
353 CONGRESS AVE.
ROCHESTER, NEW YORK 14619

SED Control No. 26-16-00-01-0-037-021



Date 01/11/19 SEI Project No. 17-3016
Revisions

PARTIAL LOWER LEVEL FLOOR
PLAN - HVAC

AD2-H1

Reference DWG. H1401



SEI
design group

585.442.7010 - 224 Mill St. - Rochester, NY 14614
518.435.2467 - 187 Wolf Rd., Suite 304 - Albany, NY 12205
607.304.4550 - 2 Court St., Suite 404 - Binghamton, NY 13901

ROCHESTER CITY SCHOOL DISTRICT

**DR. WALTER
COOPER**

SCHOOL 10
353 CONGRESS AVE.
ROCHESTER, NEW YORK 14619

SED Control No. 26-16-00-01-0-037-021




Date **01/11/19** SEI Project No. **17-3016**

Revisions

**PARTIAL SECOND FLOOR PLAN
- HVAC**

AD2-H2

Reference DWG. H1204

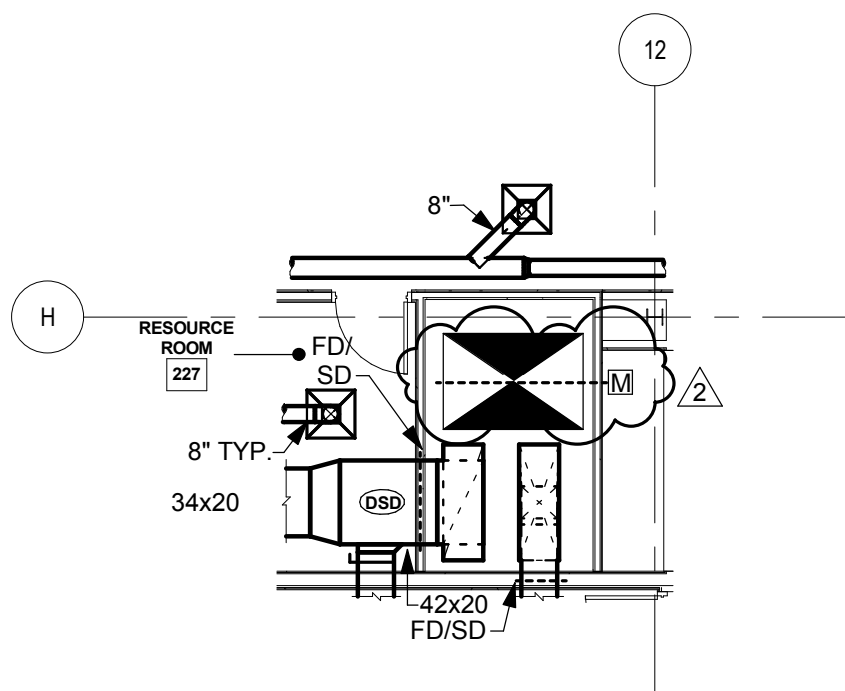

1 PARTIAL SECOND FLOOR PLAN - HVAC DUCTWORK
1/8" = 1'-0"



SEI
design group

585.442.7010 - 224 Mill St. - Rochester, NY 14614
518.435.2467 - 187 Wolf Rd., Suite 304 - Albany, NY 12205
607.304.4550 - 2 Court St., Suite 404 - Binghamton, NY 13901

ROCHESTER CITY SCHOOL DISTRICT

**DR. WALTER
COOPER**

SCHOOL 10
353 CONGRESS AVE.
ROCHESTER, NEW YORK 14619

SED Control No. 26-16-00-01-0-037-021




Date 01/11/19 SEI Project No. 17-3016

Revisions

**PARTIAL SECOND FLOOR PLAN
- HVAC**

AD2-H3

Reference DWG. H1204

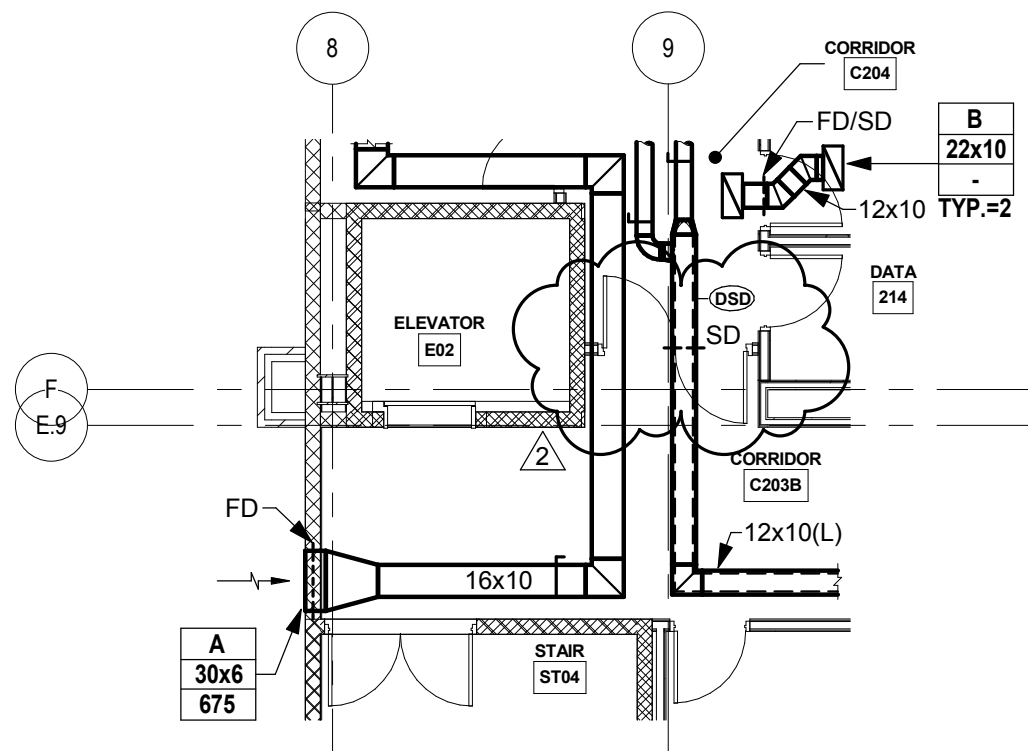

1 PARTIAL SECOND FLOOR PLAN - HVAC DUCTWORK
1/8" = 1'-0"



SEI
design group

585.442.7010 - 224 Mill St. - Rochester, NY 14614
518.435.2467 - 187 Wolf Rd., Suite 304 - Albany, NY 12205
607.304.4550 - 2 Court St., Suite 404 - Binghamton, NY 13901

ROCHESTER CITY SCHOOL DISTRICT

**DR. WALTER
COOPER**

SCHOOL 10
353 CONGRESS AVE.
ROCHESTER, NEW YORK 14619

SED Control No. 26-16-00-01-0-037-021




Date **01/11/19** SEI Project No. **17-3016**

Revisions

**PARTIAL LOWER LEVEL FLOOR
PLAN - HVAC PIPING**

AD2-H4

Reference DWG. H1301

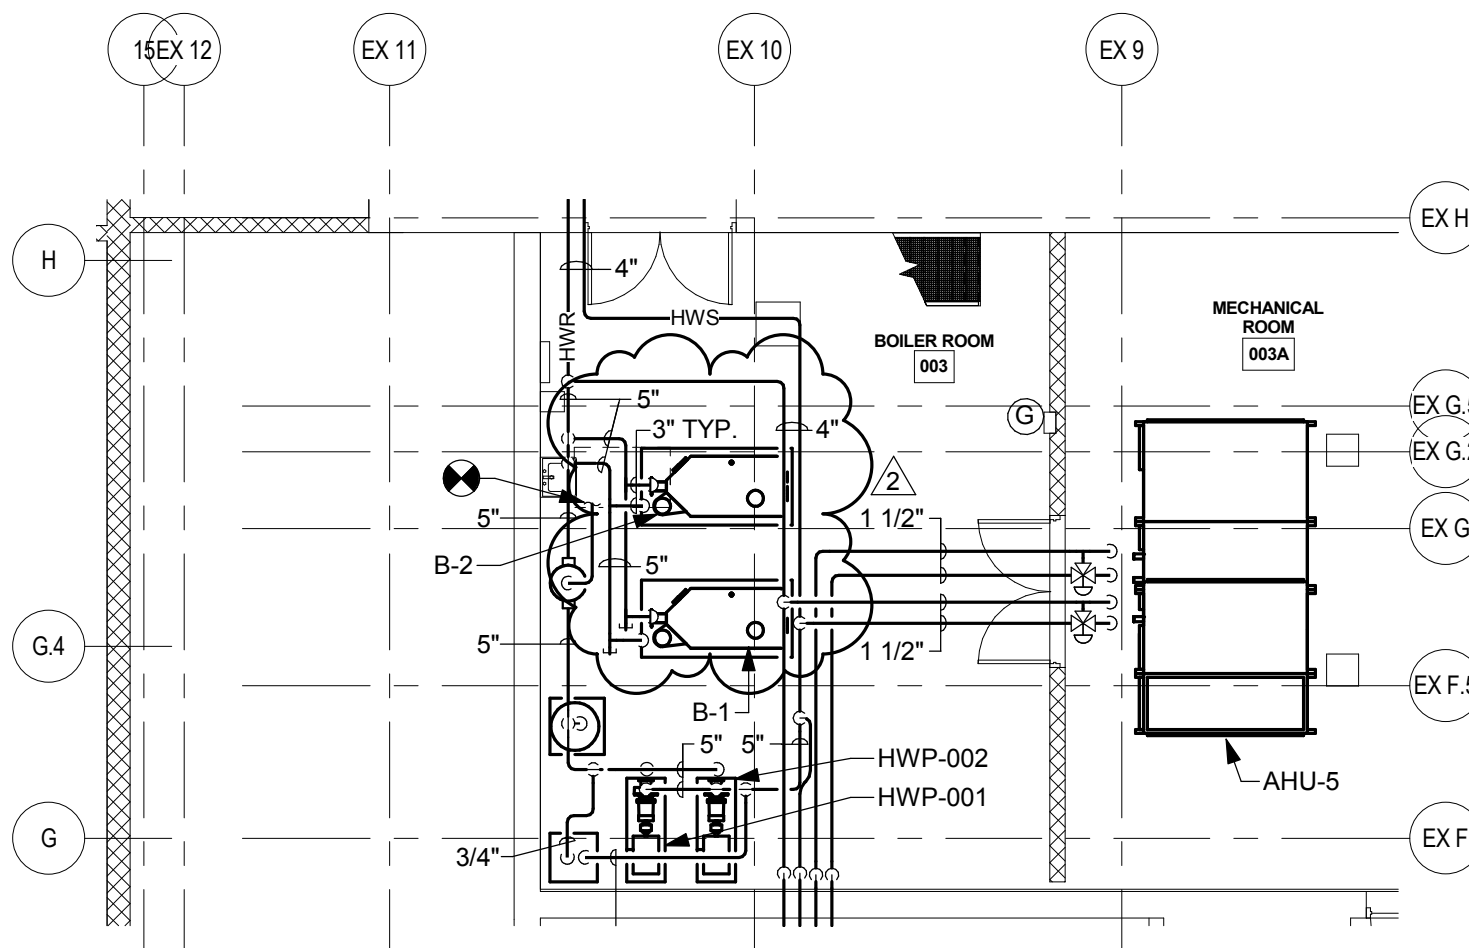

1 PARTIAL LOWER LEVEL PLAN - HVAC PIPING

1/8" = 1'-0"

1/10/2019 11:40:01 AM

CABINET UNIT HEATER SCHEDULE - HOT WATER

UNIT NO.	LOCATION	TYPE	CAPACITY (MBH)	AIR SIDE		WATER SIDE				FAN MOTOR					
				AIR FLOW (CFM)	ENT. AIR TEMP (DEG. F)	FLOW RATE (GPM)	WATER P.D. (Ft. HD)	ENT. WATER TEMP (DEG. F)	LVG. WATER TEMP (DEG. F)	FLUID	QTY	RPM	HP	VOLTS	PHASE
CUH-01	STAIR ST02	RECESSED	36.0	420	60	2.5	1.32	180	150	WATER	1	1050	1/10	120	1
CUH-02	STAIR ST01	RECESSED	36.0	420	60	2.5	1.32	180	150	WATER	1	1050	1/10	120	1
CUH-03	VESTIBULE V4	RECESSED	78.3	1040	60	5	3.5	180	150	WATER	2	1050	1/15	120	1
CUH-04	VESTIBULE V4	RECESSED	78.3	1040	60	5	3.5	180	150	WATER	2	1050	1/15	120	1
CUH-05	VESTIBULE V3	RECESSED	78.3	1040	60	5	3.5	180	150	WATER	2	1050	1/15	120	1
CUH-06	VESTIBULE V3	RECESSED	78.3	1040	60	5	3.5	180	150	WATER	2	1050	1/15	120	1
CUH-07	STAIR ST04	SURFACE	53.6	630	60	3	1.32	180	150	WATER	1	1050	1/10	120	1
CUH-08	STAIR ST03	SURFACE	53.6	630	60	3	1.32	180	150	WATER	1	1050	1/10	120	1
CUH-09	GIRLS 132	RECESSED	36.0	420	60	2.5	1.32	180	150	WATER	1	1050	1/10	120	1
CUH-10	BOYS 142	RECESSED	36.0	420	60	2.5	1.32	180	150	WATER	1	1050	1/10	120	1
CUH-11	VESTIBULE V5	RECESSED	78.3	1040	60	5	3.5	180	150	WATER	2	1050	1/15	120	1
CUH-12	VESTIBULE V2	RECESSED	78.3	1040	60	5	3.5	180	150	WATER	2	1050	1/15	120	1
CUH-13	VESTIBULE V1	RECESSED	78.3	1040	60	5	3.5	180	150	WATER	2	1050	1/15	120	1

- REMARKS:
1. PROVIDE UNIT WITH ECM MOTOR AND 3-SPEED SWITCH.
 2. PROVIDE UNIT WITH COLOR SELECTED BY ARCHITECT.
 3. PROVIDE UNIT WITH DISCONNECT SWITCH.
 4. PROVIDE UNIT WITH S/S RELAY AND FAN OP. RELAY & TRANSFORMER.
 5. PROVIDE UNIT WITH TWO ROW COIL.
 6. PROVIDE SUPPLY AND RETURN DUCT COLLARS.

NOMINAL DIMENSIONS			MANUFACTURER & MODEL No.	REMARKS
LENGTH (In.)	HEIGHT (In.)	DEPTH (In.)		
47	25	9.5	STERLING RC-1200-04	1,2,3,4,5
47	25	9.5	STERLING RC-1200-04	1,2,3,4,5
66	25	9.5	STERLING RC-1200-10	1,2,3,4,5
66	25	9.5	STERLING RC-1200-10	1,2,3,4,5
66	25	9.5	STERLING RC-1200-10	1,2,3,4,5
66	25	9.5	STERLING RC-1200-10	1,2,3,4,5
66	25	9.5	STERLING RC-1200-10	1,2,3,4,5
59	25	9.5	STERLING W-1080-06	1,2,3,4,5
59	25	9.5	STERLING W-1080-06	1,2,3,4,5
47	25	9.5	STERLING RC-1200-04	1,2,3,4,5
47	25	9.5	STERLING RC-1200-04	1,2,3,4,5
66	25	9.5	STERLING RC-1200-10	1,2,3,4,5
66	25	9.5	STERLING RC-1200-10	1,2,3,4,5
66	25	9.5	STERLING RC-1200-10	1,2,3,4,5



SEI
design group

585.442.7010 - 224 Mill St. - Rochester, NY 14614
518.435.2467 - 187 Wolf Rd., Suite 304 - Albany, NY 12205
607.304.4550 - 2 Court St., Suite 404 - Binghamton, NY 13901

ROCHESTER CITY
SCHOOL DISTRICT

DR. WALTER
COOPER, SCHOOL
#10

SCHOOL 10
353 CONGRESS AVE.
ROCHESTER, NEW YORK 14619

SED Control No. 26-16-00-01-0-037-021



Date 01/11/19 SEI Project No. 17-3016
Revisions

CABINET UNIT HEATER
SCHEDULE - HVAC

AD2 - H5

Reference DWG. H1600

PUMP SCHEDULE

PUMP NO.	LOCATION	SERVICE	UNIT TYPE & DESCRIPTION	PUMP CAPACITY		MAX WWP	MOTOR CHARACTERISTICS					IMPELLER SIZE (DIA. In.)	FLUID TEMP. (° F)	MIN. PUMP EFF. (%)
				FLOW (GPM)	TOTAL HEAD IN FEET		RPM	HP	VOLTS	PHASE	STARTER			
BP-001	MECH ROOM	B-001	INLINE PUMP	113	20	-	1750	1	460	3	VFD BY DIV 26	5.7"	180	63
BP-002	MECH ROOM	B-002	INLINE PUMP	113	20	-	1750	1	460	3	VFD BY DIV 26	5.7"	180	65
HWP-001	MECH ROOM	HW LOOP	BASE MTD	415	90	-	1750	15	460	3	VFD BY DIV 26	9.9"	180	76
HWP-002	MECH ROOM	HW LOOP	BASE MTD	415	90	-	1750	15	460	3	VFD BY DIV 26	9.9"	180	76
HWCP-1	MECH ROOM	AHU-1	INLINE	42.1	20	-	3450	1/2	115	1	BY DIV 26	N/A	180	N/A
HWCP-2	MECH ROOM	AHU-2	INLINE	10.1	15	-	3450	1/8	115	1	BY DIV 26	N/A	180	N/A
HWCP-3	MECH ROOM	AHU-3	INLINE	10.1	15	-	3450	1/8	115	1	BY DIV 26	N/A	180	N/A
HWCP-4	MECH ROOM	AHU-4	INLINE	14.3	15	-	3450	1/8	115	1	BY DIV 26	N/A	180	N/A
HWCP-5	MECH ROOM	AHU-5	INLINE	14	15	-	3450	1/8	115	1	BY DIV 26	N/A	180	N/A
HWCP-6	MECH ROOM	AHU-6	INLINE	10.1	15	-	3450	1/8	115	1	BY DIV 26	N/A	180	N/A
CWP-001	MECH ROOM	CW LOOP	BASE MTD	390	80	-	1750	15	460	3	VFD BY DIV 26	9.6"	44	77
CWP-002	MECH ROOM	CW LOOP	BASE MTD	390	80	-	1750	15	460	3	VFD BY DIV 26	9.6"	44	77
CWP-003	MECH ROOM	CH-1 PUMP	BASE MTD	287	40	-	1750	5	460	3	VFD BY DIV 26	7.1"	44	77
CWP-004	MECH ROOM	CH-2 PUMP	INLINE	46	35	-	1750	1	460	3	VFD BY DIV 26	6.4"	44	50

REMARKS:
1. PROVIDE INERTIA BASE.

MIN. PUMP EFF. (%)	MAX. BHP	SUCTION & DISCHARGE SIZES	MULTI PURPOSE VALVE SIZE	SUCTION DIFFUSER SIZE	MANUFACTURER & MODEL No.	REMARKS
63	.95	2"x 2"	N/A	N/A	TACO 1935	
65	.95	2"x 2"	N/A	N/A	TACO 1935	
76	13.07	4"x 3"	4"	5"x 4"	TACO FI3011D	
76	13.07	4"x 3"	4"	5"x 4"	TACO FI3011D	
N/A	N/A	1-1/2"	N/A	N/A	TACO 2400-70	
N/A	N/A	1-1/2"	N/A	N/A	TACO 0011-F4	
N/A	N/A	1-1/2"	N/A	N/A	TACO 0011-F4	
N/A	N/A	1-1/2"	N/A	N/A	TACO 0011-F4	
N/A	N/A	1-1/2"	N/A	N/A	TACO 0011-F4	
N/A	N/A	1-1/2"	N/A	N/A	TACO 0011-F4	
77	11.39	3"x 2 1/2"	4"	5"x 3"	TACO FI2510C	1
77	11.39	3"x 2 1/2"	4"	5"x 3"	TACO FI2510C	1
77	4.29	3"x 2 1/2"	3"	4"x 3"	TACO FI2507D	1
50	.95	2"x 2"	1 1/2"	NA	TACO 1935	



ROCHESTER CITY
SCHOOL DISTRICT

DR. WALTER
COOPER, SCHOOL
#10

SCHOOL 10
353 CONGRESS AVE.
ROCHESTER, NEW YORK 14619

SED Control No. 26-16-00-01-0-037-021



Date 01/11/19 SEI Project No. 17-3016
Revisions

PUMP SCHEDULE -
HVAC

AD2 - H6

Reference DWG. H1600



SEI
design group

585.442.7010 - 224 Mill St. - Rochester, NY 14614
518.435.2467 - 187 Wolf Rd., Suite 304 - Albany, NY 12205
607.304.4550 - 2 Court St., Suite 404 - Binghamton, NY 13901

ROCHESTER CITY SCHOOL DISTRICT

**DR. WALTER
COOPER**

SCHOOL 10
353 CONGRESS AVE.
ROCHESTER, NEW YORK 14619

SED Control No. 26-16-00-01-0-037-021




Date **01/11/19** SEI Project No. **17-3016**

Revisions


**PARTIAL SECOND FLOOR PLAN
- POWER AND SS - AREA A**

AD2-E1

Reference DWG. E1204

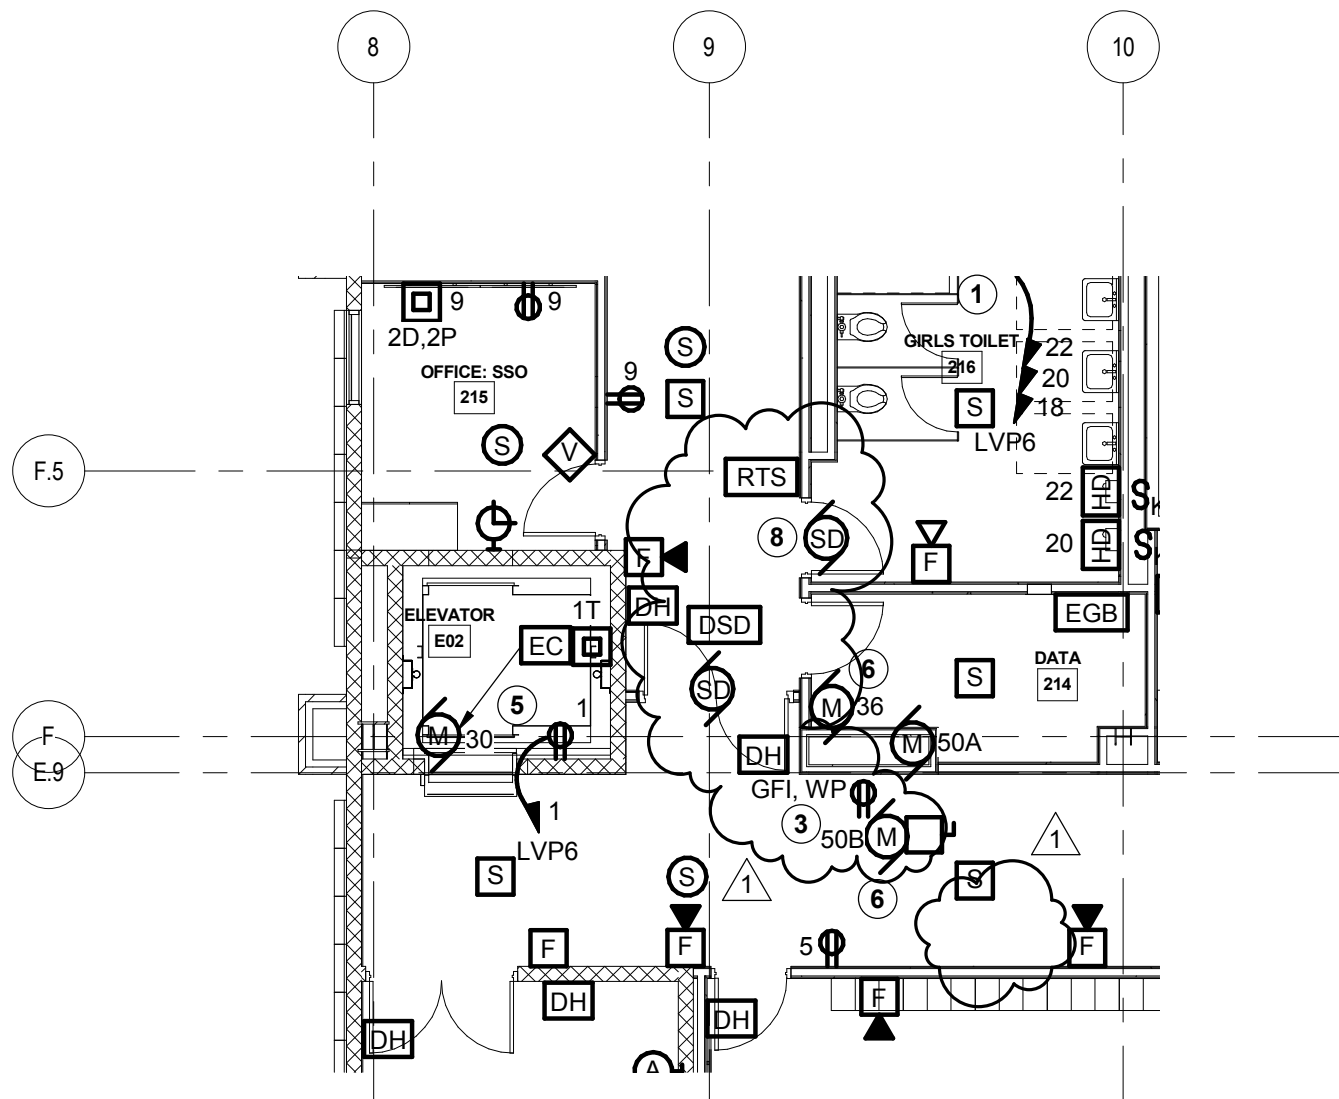

 1 PARTIAL SECOND FLOOR PLAN - POWER AND SS
1/8" = 1'-0"



585.442.7010 - 224 Mill St. - Rochester, NY 14614
518.435.2467 - 187 Wolf Rd., Suite 304 - Albany, NY 12205
607.304.4550 - 2 Court St., Suite 404 - Binghamton, NY 13901

Reference DWG. E1205





SEI
design group

585.442.7010 - 224 Mill St. - Rochester, NY 14614
518.435.2467 - 187 Wolf Rd., Suite 304 - Albany, NY 12205
607.304.4550 - 2 Court St., Suite 404 - Binghamton, NY 13901

ROCHESTER CITY SCHOOL DISTRICT

**DR. WALTER
COOPER**

SCHOOL 10
353 CONGRESS AVE.
ROCHESTER, NEW YORK 14619

SED Control No. 26-16-00-01-0-037-021




Date **01/11/19** SEI Project No. **17-3016**

Revisions

**PARTIAL SECOND FLOOR PLAN
- LIGHTING - AREA A**

AD2-E3

Reference DWG. E1304

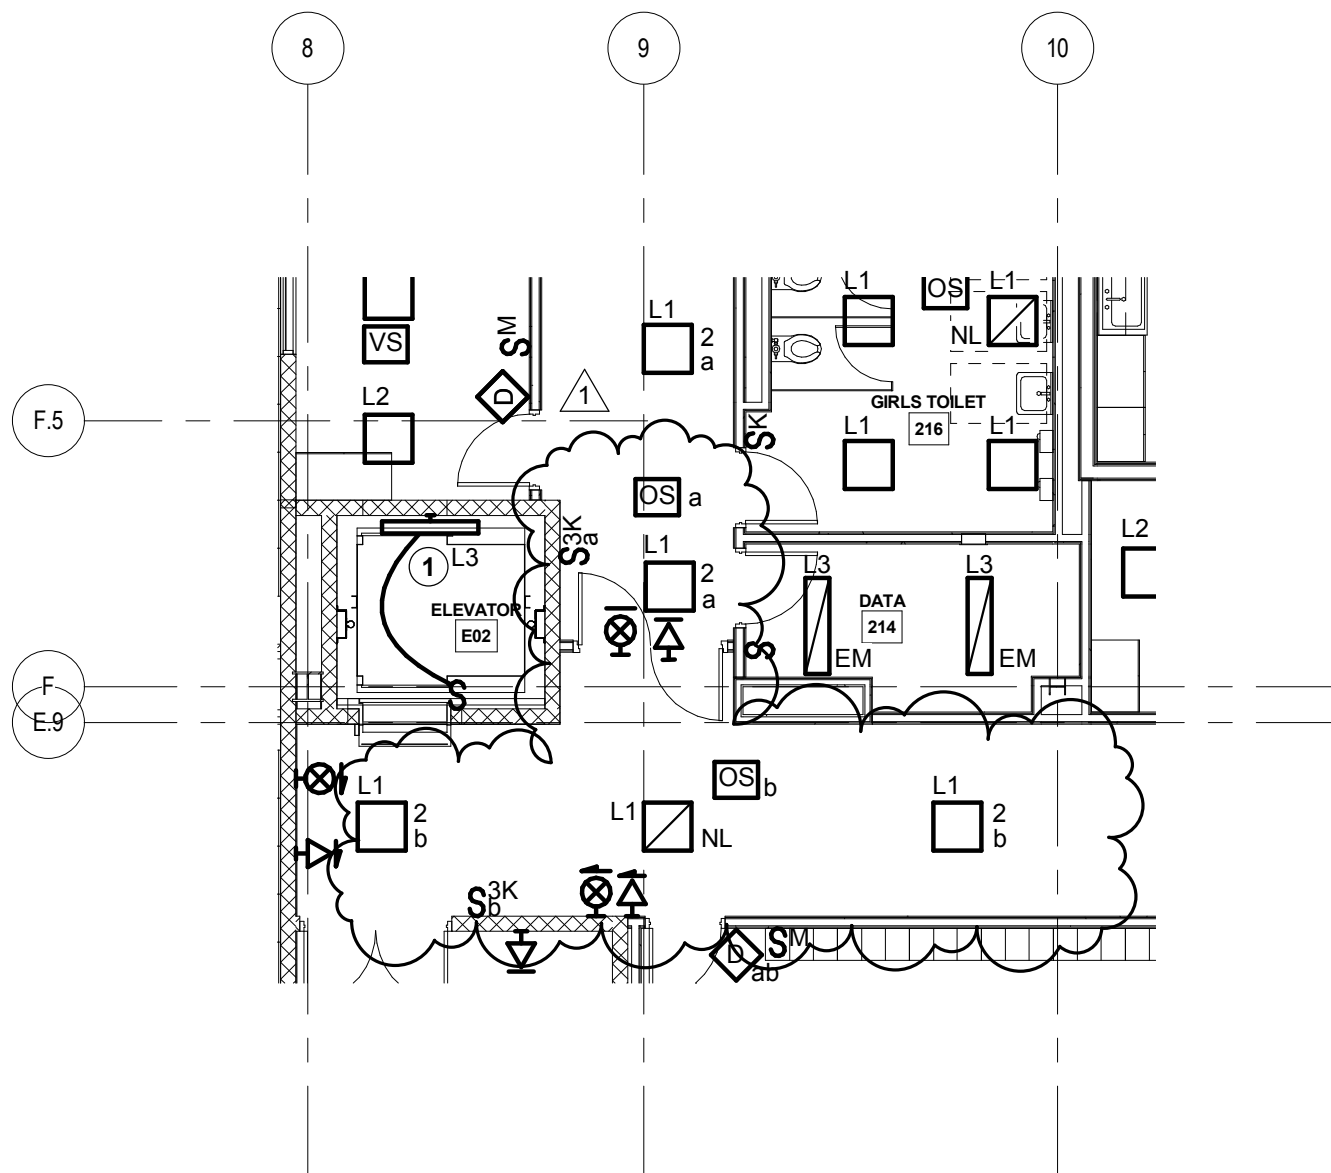

1 PARTIAL SECOND FLOOR PLAN - LIGHTING
1/8" = 1'-0"

1/7/2019 4:34:28 PM



SEI
design group

585.442.7010 - 224 Mill St. - Rochester, NY 14614
518.435.2467 - 187 Wolf Rd., Suite 304 - Albany, NY 12205
607.304.4550 - 2 Court St., Suite 404 - Binghamton, NY 13901

ROCHESTER CITY SCHOOL DISTRICT

**DR. WALTER
COOPER**

SCHOOL 10
353 CONGRESS AVE.
ROCHESTER, NEW YORK 14619

SED Control No. 26-16-00-01-0-037-021




Date **01/11/19** SEI Project No. **17-3016**

Revisions

**PARTIAL SECOND FLOOR PLAN
- LIGHTING - AREA B**

AD2-E4

Reference DWG. E1305

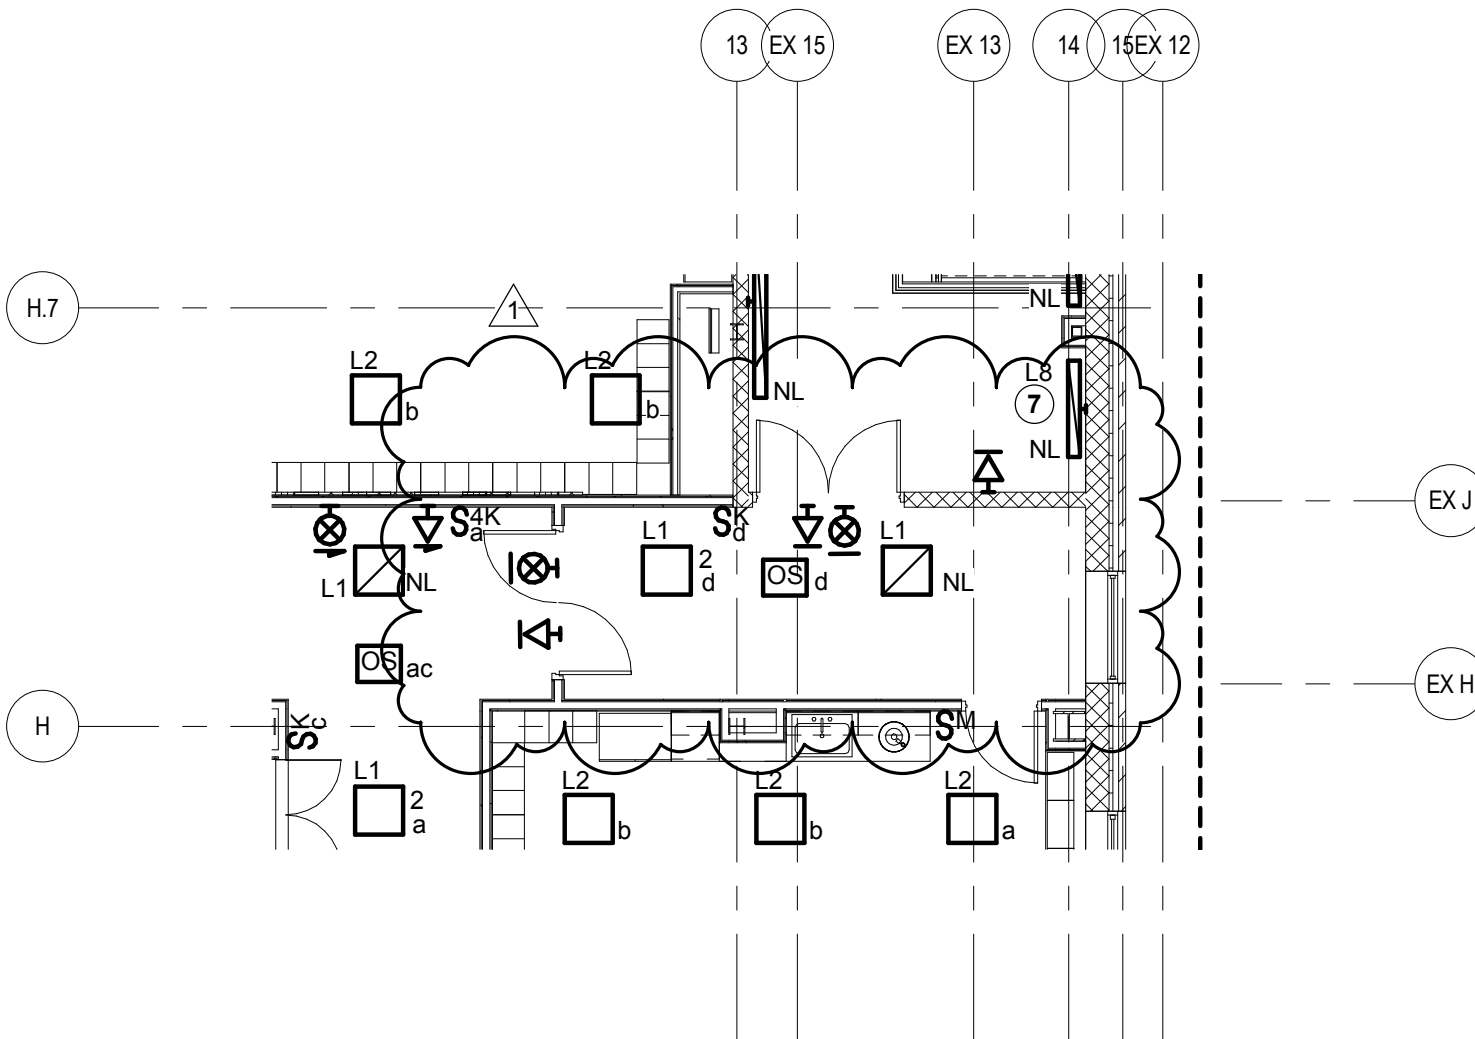

1 PARTIAL SECOND FLOOR PLAN - LIGHTING

1/8" = 1'-0"

1/7/2019 4:34:28 PM


11/2019 10:42:46 AM

© SEI design group Architects


DOOR SCHEDULE															
DOOR NO.	HARDWARE	DOOR				FRAME				RATING (IN MINUTES)	GLAZING TYPE				REMARKS
		LEAFS	WIDTH	HEIGHT	THICK	TYPE	MATERIAL - FINISH	TYPE	MATERIAL - FINISH	JAMB DETAIL	HEAD DETAIL				
001-1	01	1	3'-0"	7'-0"	0'-1 3/4"	F	HM-PT	F2	HM-PT	J2	H2	-	-	-	
002-1	02	1	3'-0"	7'-0"	0'-1 3/4"	F	HM-PT	F2	HM-PT	J6	H6	45	-	-	V.I.F.
002A-1	01	1	3'-0"	7'-0"	0'-1 3/4"	F	HM-PT	F2	HM-PT	J2	H2	45	-	-	
003-1	08	2	3'-0"	6'-8"	0'-1 3/4"	F	HM-PT	F2	HM-PT	J6	H6	90	-	-	V.I.F.
003-2	01	1	3'-0"	7'-0"	0'-1 3/4"	F	HM-PT	F1	HM-PT	J6	H6	90	-	-	V.I.F.
003A-1	9	2	3'-0"	7'-0"	0'-1 3/4"	F	HM-PT	F2	HM-PT	J2	H2	90	-	-	
004-1	03	1	3'-0"	7'-0"	0'-1 3/4"	F	HM-PT	F2	HM-PT	J6	H6	45	-	-	V.I.F.
004-2	11	2	2'-6"	8'-0"	0'-1 3/4"	F	HM-PT	F2	HM-PT	J6	H6	45	-	-	ALTERNATE NO. 10
005-1	08	2	3'-0"	7'-0"	0'-1 3/4"	F	HM-PT	F2	HM-PT	J2	H2	90	-	-	
006-1	08	2	3'-0"	7'-0"	0'-1 3/4"	F	HM-PT	F2	HM-PT	J2	H2	90	-	-	
007-1	14	2	3'-0"	7'-0"	0'-1 3/4"	F	HM-PT	F2	HM-PT	J2	H2	90	-	-	
008-1	03	1	3'-0"	7'-0"	0'-1 3/4"	F	HM-PT	F2	HM-PT	J2	H2	-	-	-	
009-1	03	1	3'-0"	7'-0"	0'-1 3/4"	F	HM-PT	F2	HM-PT	J2	H2	-	-	-	
100-1	15	1	3'-0"	7'-0"	0'-1 3/4"	D	WD-ST	F1	HM-PT	J1	H1	20	FG-1	-	
100-2	16	1	3'-0"	7'-0"	0'-1 3/4"	D	WD-ST	F1	HM-PT	J6	H6	20	FG-1	-	
100A	17	1	3'-0"	7'-0"	0'-1 3/4"	F	WD-ST	F1	WD-ST	J13	H1	-	-	-	
100B	18	1	3'-0"	7'-0"	0'-1 3/4"	F	WD-ST	F1	HM-PT	J1	H1	-	-	-	
100C-1	20	1	3'-0"	7'-0"	0'-1 3/4"	F	WD-ST	F1	HM-PT	J1	H1	-	-	-	
100C-2	21	1	3'-0"	6'-0"	0'-1 3/4"	F	WD-ST	F1	HM-PT	J1	H1	90	-	-	
101-1	15	1	3'-0"	7'-0"	0'-1 3/4"	D	WD-ST	F1	HM-PT	J1	H1	20	FG-1	-	
101-2	24	1	3'-0"	7'-0"	0'-1 3/4"	D	WD-ST	F1	HM-PT	J6	H6	20	FG-1	-	
101A	18	1	3'-0"	7'-0"	0'-1 3/4"	F	WD-ST	F1	HM-PT	J1	H1	-	-	-	
101B-1	21	1	3'-0"	7'-0"	0'-1 3/4"	F	WD-ST	F1	HM-PT	J1	H1	-	-	-	
102-1	1	1	3'-0"	7'-0"	0'-1 3/4"	NL	WD-ST	F1	HM-PT	J1	H1	20	FG-1	-	
102-2	26	1	3'-0"	7'-0"	0'-1 3/4"	NL	WD-ST	F1	HM-PT	J1	H1	20	FG-1	-	
103	78	1	3'-0"	7'-0"	0'-1 3/4"	NL	ALUM-FF	F15	ALUM-FF	J8	H1	-	-	-	IG-1
103-1	26	1	3'-0"	7'-0"	0'-1 3/4"	NL	WD-ST	F1	HM-PT	J1	H1	20	FG-1	-	
104-1	26	1	3'-0"	7'-0"	0'-1 3/4"	NL	WD-ST	F1	HM-PT	J1	H1	20	FG-1	-	
105-1	26	1	3'-0"	7'-0"	0'-1 3/4"	NL	WD-ST	F1	HM-PT	J1	H1	20	FG-1	-	
105-2	29	1	3'-0"	7'-0"	0'-1 3/4"	NL	AMP-FF	F6	ALUM-FF	J6	H6	-	-	-	V.I.F.
106-1	26	1	3'-0"	7'-0"	0'-1 3/4"	NL	WD-ST	F1	HM-PT	J1	H1	20	FG-1	-	
106-2	31	2	2'-6"	7'-0"	0'-1 3/4"	D	AMP-FF	F6	ALUM-FF	J6	H6	-	-	-	V.I.F.
106A	33	1	3'-0"	7'-0"	0'-1 3/4"	DD	WD-ST	F1	HM-PT	J1	H1	-	-	-	
106B	34	1	3'-0"	7'-0"	0'-1 3/4"	F	WD-ST	F1	HM-PT	J1	H1	-	-	-	
107-1	26	1	3'-0"	7'-0"	0'-1 3/4"	NL	WD-ST	F1	HM-PT	J1	H1	20	FG-1	-	
108-1	26	1	3'-0"	7'-0"	0'-1 3/4"	NL	WD-ST	F1	HM-PT	J1	H1	20	FG-1	-	
108-2	31	2	2'-6"	7'-0"	0'-1 3/4"	D	AMP-FF	F7	ALUM-FF	J6	H6	-	-	-	V.I.F.
108A	33	1	3'-0"	7'-0"	0'-1 3/4"	DD	WD-ST	F1	HM-PT	J1	H1	-	-	-	
108B	34	1	3'-0"	7'-0"	0'-1 3/4"	F	WD-ST	F1	HM-PT	J1	H1	-	-	-	
109-1	26	1	3'-0"	7'-0"	0'-1 3/4"	NL	WD-ST	F1	HM-PT	J1	H1	20	FG-1	-	
109-2	31	2	2'-6"	7'-0"	0'-1 3/4"	D	AMP-FF	F7	ALUM-FF	J6	H6	-	-	-	IG-1
109A	33	1	3'-0"	7'-0"	0'-1 3/4"	DD	WD-ST	F1	HM-PT	J1	H1	-	-	-	
110-1	26	1	3'-0"	7'-0"	0'-1 3/4"	NL	WD-ST	F1	HM-PT	J1	H1	20	FG-1	-	
110A	34	1	3'-0"	7'-0"	0'-1 3/4"	F	WD-ST	F1	HM-PT	J1	H1	-	-	-	
110B	35	1	3'-0"	7'-0"	0'-1 3/4"	F	WD-ST	F1	HM-PT	J1	H1	-	-	-	
111-1	26	1	3'-0"	7'-0"	0'-1 3/4"	NL	WD-ST	F1	HM-PT	J1	H1	20	FG-1	-	
111-2	29	1	3'-0"	7'-0"	0'-1 3/4"	D	AMP-FF	F8	ALUM-FF	J4	H4	-	-	-	IG-1
111A	33	1	3'-0"	7'-0"	0'-1 3/4"	DD	WD-ST	F1	HM-PT	J1	H1	-	-	-	
112-1	26	1	3'-0"	7'-0"	0'-1 3/4"	NL	WD-ST	F1	HM-PT	J1	H1	20	FG-1	-	
113-1	26	1	3'-0"	7'-0"	0'-1 3/4"	NL	WD-ST	F1	HM-PT	J1	H1	20	FG-1	-	
114-1	27	1	3'-0"	7'-0"	0'-1 3/4"	NL	WD-ST	F1	HM-PT	J1	H1	20	FG-1	-	
115-1	39	2	3'-0"	7'-0"	0'-1 3/4"	F	HM-PT	F2	HM-PT	J2	H2	90	-	-	ALTERNATE NO. 10
115-2	40	1	3'-0"	7'-0"	0'-1 3/4"	NL	FRP-FF	F2	ALUM-FF	J4	H4	90	FG-4	-	
115-3	41	1	12'-0"	8'-0"	0'-1 1/2"	SEE SPEC	STEEL-FF	F1	MFR.	J12	H8	90	-	-	COILING STEEL OVERHEAD DOOR
115A	20	1	3'-0"	7'-0"	0'-1 3/4"	NL	HM-PT	F2	HM-PT	J2	H2	-	-	-	MG-1
115B	19	1	3'-0"	7'-0"	0'-1 3/4"	F	HM-PT	F2	HM-PT	J2	H2	-	-	-	
115C-1	41	1	8'-0"	8'-0"	0'-1 1/2"	SEE SPEC	WD-ST	F1	MFR.	J12	H8	90	-	-	COILING STEEL OVERHEAD DOOR
115C-2	41	1	8'-0"	8'-0"	0'-1 1/2"	SEE SPEC	WD-ST	F1	MFR.	J12	H8	90	-	-	COILING STEEL OVERHEAD DOOR
116-1	26	1	3'-0"	7'-0"	0'-1 3/4"	NL	WD-ST	F1	HM-PT	J1	H1	20	FG-1	-	
117-1	42	1	3'-0"	7'-0"	0'-1 3/4"	F	WD-ST	F1	HM-PT	J2	H2	20	-	-	
118-1	42	1	3'-0"	7'-0"	0'-1 3/4"	F	WD-ST	F1	HM-PT	J1	H1	20	-	-	
119-1	43	1	3'-4"	7'-0"	0'-1 3/4"	DL	FRP-FF	F8	ALUM-FF	J4	H4	-	-	-	IG-1
119-2	44	2	3'-0"	7'-0"	0'-1 3/4"	NL	HM-PT	F2	HM-PT	J2	H2	20	FG-1	-	ALTERNATE NO. 10
119-3	44	2	3'-0"	7'-0"	0'-1 3/4"	NL	HM-PT	F2	HM-PT	J2	H2	20	FG-1	-	ALTERNATE NO. 10
119A	61	1	3'-0"	7'-0"	0'-1 3/4"	F	HM-PT	F2	HM-PT	J2	H2	-	-	-	ALTERNATE NO. 10
119B	46	2	3'-0"	7'-0"	0'-1 3/4"	F	HM-PT	F2	HM-PT	J2	H2	-	-	-	ALTERNATE NO. 10
120-1	50	1	3'-8"	7'-0"	0'-1 3/4"	NL	FRP-FF	F8	ALUM-FF	J4	H4	45	FG-2	-	
120-2	51	1	3'-0"	7'-0"	0'-1 3/4"	NL	FRP-FF	F8	ALUM-FF	J4	H4	-	-	-	IG-1
120-3	26	1	3'-0"	7'-0"	0'-1 3/4"	NL	HM-PT	F2	HM-PT	J2	H2	45	FG-2	-	ALTERNATE NO. 10
120A	34	1	3'-0"	7'-0"	0'-1 3/4"	F	HM-PT	F2	HM-PT	J2	H2	-	-	-	ALTERNATE NO. 10
120B	20	1	3'-0"	7'-0"	0'-1 3/4"	NL	HM-PT	F2	HM-PT	J2	H2	-	-	-	MG-1
120C-1	52	1	3'-0"	7'-0"	0'-1 3/4"	DL	ALUM-FF	F13	ALUM-FF	J8	H8	45	FG-2	-	
120C-2	52	1	3'-0"	7'-0"	0'-1 3/4"	DL	ALUM-FF	F14	ALUM-FF	J8	H8	45	FG-2	-	
120D	04	1	3'-0"	7'-0"	0'-1 3/4"	F	HM-PT	F2	HM-PT	J2	H2	-	-	-	ALTERNATE NO. 10
120E	53	1	3'-0"	7'-0"	0'-1 3/4"	F	HM-PT	F2	HM-PT	J2	H2	-	-	-	ALTERNATE NO. 10
120F	18	1	3'-0"	7'-0"	0'-1 3/4"	F	HM-PT	F2	HM-PT	J2	H2	-	-	-	ALTERNATE NO. 10
121-1	12	2	3'-0"	7'-0"	0'-1 3/4"	F	HM-PT	F2	HM-PT	J2	H2	90	-	-	ALTERNATE NO. 10
122-1	45	2	3'-0"	7'-0"	0'-1 3/4"	NL	HM-PT	F2	HM-PT	J2	H2	20	FG-1	-	ALTERNATE NO. 10
122-2	45	2	3'-0"	7'-0"	0'-1 3/4"	NL	HM-PT	F2	HM-PT	J2	H2	20	FG-1	-	ALTERNATE NO. 10
122-3	54	2	3'-0"	7'-0"	0'-1 3/4"	NL	FRP-FF	F16	ALUM-FF	J4	H8	-	-	-	IG-1
122-4	54	2	3'-0"	7'-0"	0'-1 3/4"	NL	FRP-FF	F16	ALUM-FF	J4	H8	-	-	-	IG-1
122-5	47	2	2'-6"	7'-0"	0'-1 3/4"	NL	HM-PT	F2	HM-PT	J2	H2	-	-	-	ALTERNATE NO. 10
122B	56	1	3'-0"	7'-0"	0'-1 3/4"	NL	HM-PT	F2	HM-PT	J2	H2	-	-	-	MG-1
122C	20	1	3'-0"	7'-0"	0'-1 3/4"	F	HM-PT	F2	HM-PT	J2	H2	-	-	-	ALTERNATE NO. 10
122D	18	1	3'-0"	7'-0"	0'-1 3/4"	F	HM-PT	F2	HM-PT	J2	H2	-	-	-	
122E	48	2	3'-0"	7'-0"	0'-1 3/4"	F	HM-PT	F2	HM-PT	J2	H2	-	-	-	ALTERNATE NO. 10
123-1	57	1	3'-0"	7'-0"	0'-1 3/4"	F	HM-PT	F2	HM-PT	J2	H2	90	-	-	ALTERNATE NO. 10
124-1	57	1	3'-0"	7'-0"	0'-1 3/4"	F	HM-PT	F2	HM-PT	J2	H2	90	-	-	ALTERNATE NO. 10
125-1	27	1	3'-0"	7'-0"	0'-1 3/4"	NL	WD-ST	F1	HM-PT	J1	H1	20	FG-1	-	
126-1	27	1	3'-0"	7'-0"	0'-1 3/4"	NL	WD-ST	F1	HM-PT	J1	H1	20	FG-1	-	
126A	20	1	3'-0"	7'-0"	0'-1 3/4"	NL	WD-ST	F1	HM-PT	J1	H1	-	-	-	MG-1
126B	20	1	3'-0"	7'-0"	0'-1 3/4"	NL	WD-ST	F1	HM-PT	J1	H1	-	-	-	MG-1
127-1	26	1	3'-0"	7'-0"	0'-1 3/4"	NL	WD-ST	F1	HM-PT	J1	H1	20	FG-1	-	
128-1	27	1	3'-0"	7'-0"	0'-1 3/4"	NL	WD-ST	F1	HM-PT	J1	H1	20	FG-1	-	
128-2	79	1	3'-0"	7'-0"	0'-1 3/4"	NL	WD-ST	F1	HM-PT	J1	H1	-	-	-	
128A	36	1	3'-0"	7'-0"	0'-1 3/4"	F	WD-ST	F1	HM-PT	J1	H1	-	-	-	
129-1	26	1	3'-0"	7'-0"	0'-1 3/4"	NL	WD-ST	F1	HM-PT	J1	H1	20	FG-1	-	
130-1	42	1	3'-0"	7'-0"	0'-1 3/4"	F	WD-ST	F1	HM-PT	J1	H1	20	-	-	
131-1	42	1	3'-0"	7'-0"	0'-1 3/4"	F	WD-ST	F1	HM-PT	J1	H1	20	-	-	
132-1	57	1	3'-0"	7'-0"	0'-1 3/4"	F	WD-ST	F1	HM-PT	J6	H6	20	-	-	

1/11/19 9:52:01 AM

© SEI design group Architects

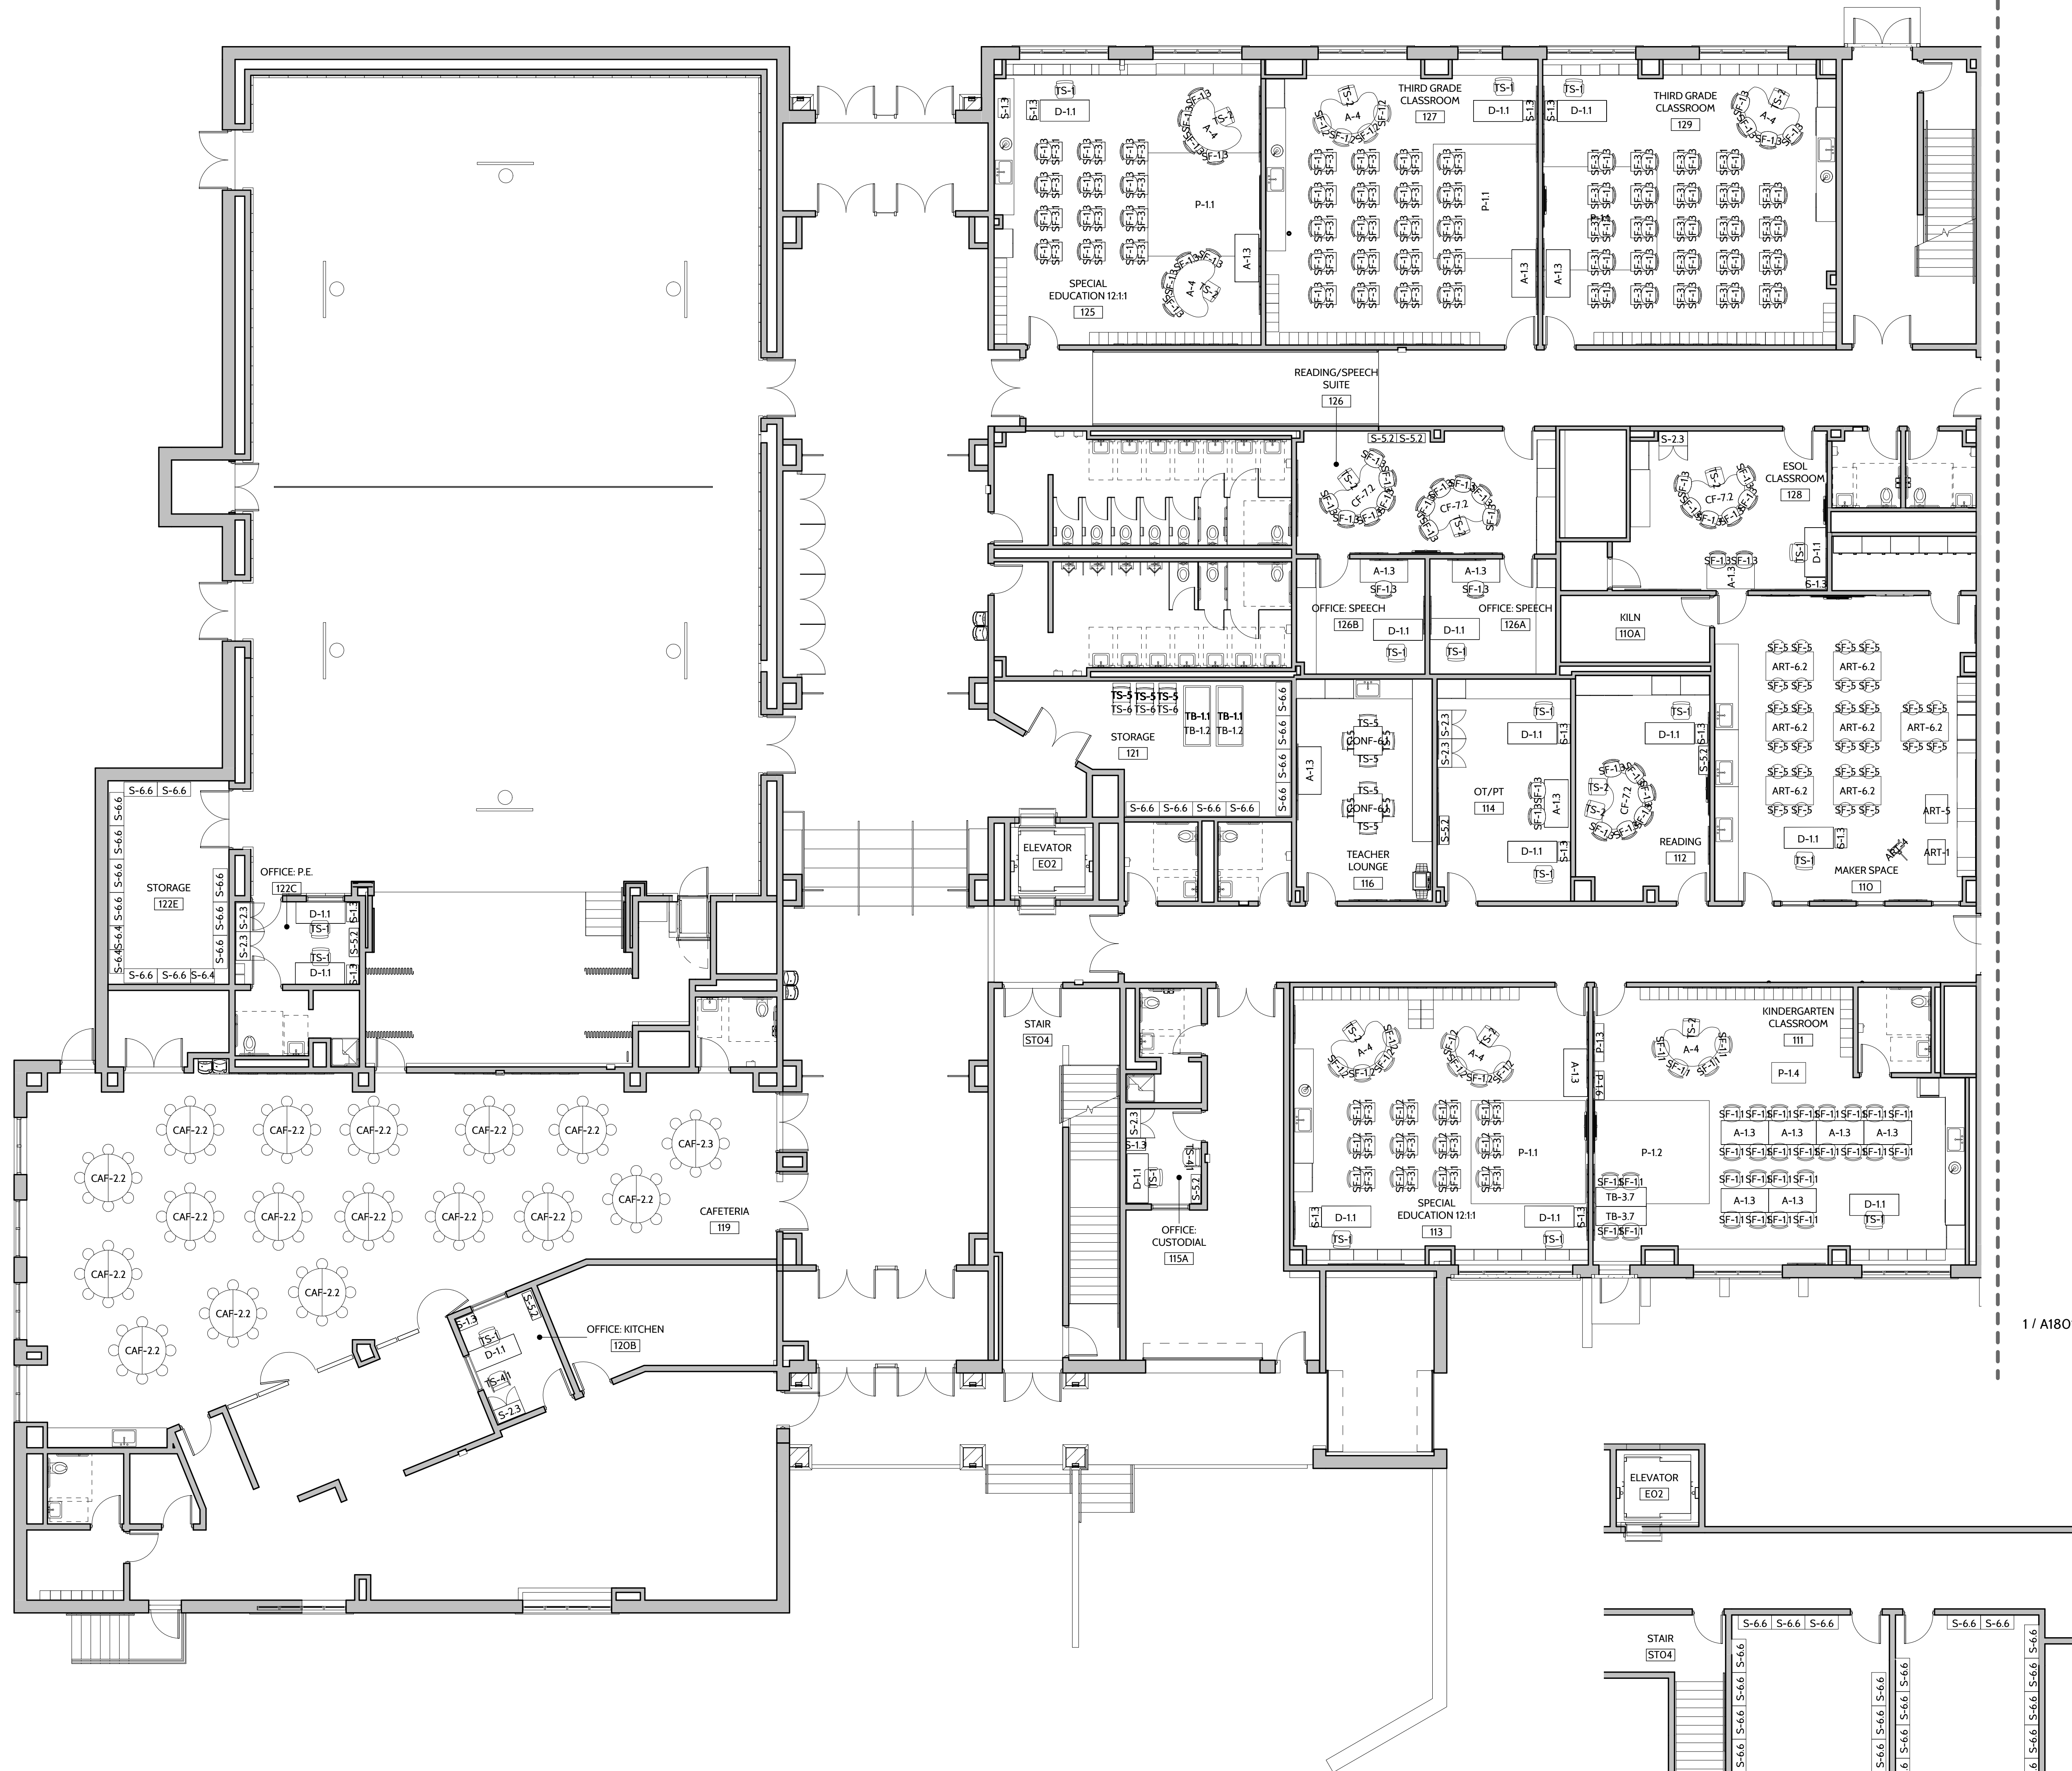

1 FIRST FLOOR FURNITURE PLAN - AREA A
1/8" = 1'-0"

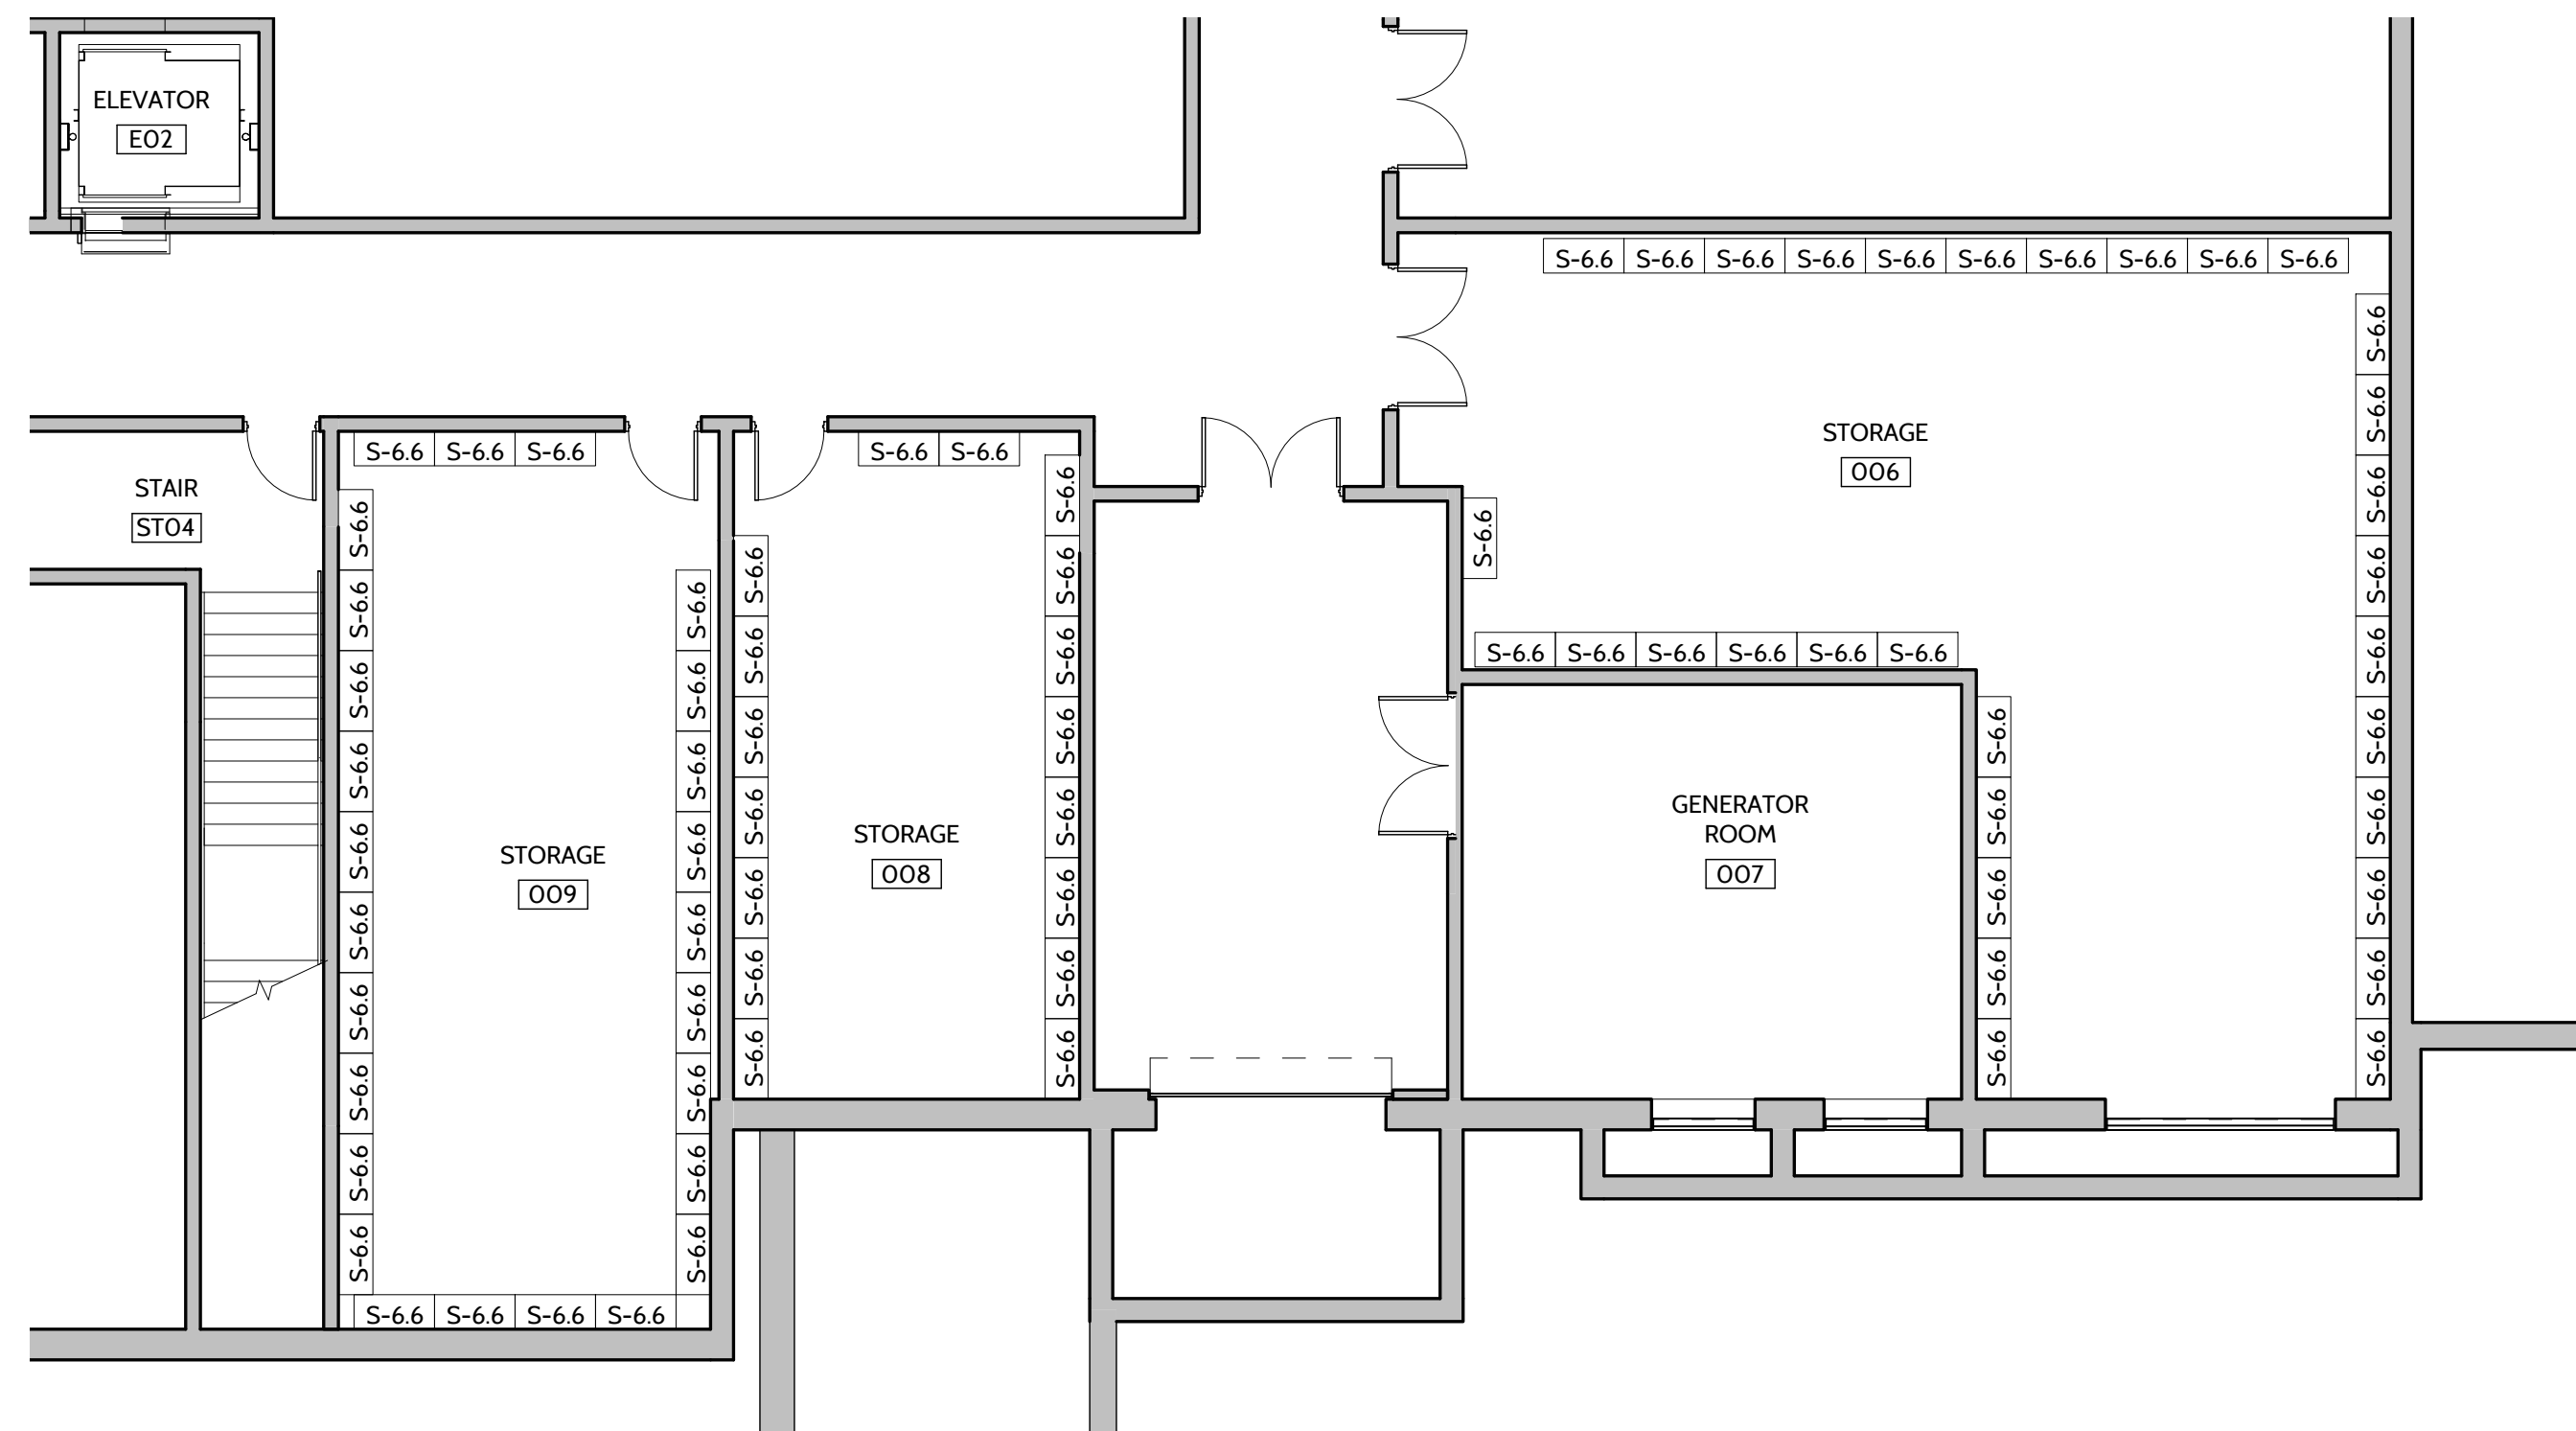

2 PARTIAL LOWER LEVEL FURNITURE PLAN
1/8" = 1'-0"

GENERAL NOTE:
THE FURNITURE WILL BE FURNISHED BY OTHERS AND THE INTENT
OF THIS DRAWING IS FOR COORDINATION PURPOSES ONLY.

ROCHESTER CITY
SCHOOL DISTRICT




Every child is a work of art.
Create a masterpiece.

DR. WALTER COOPER

SCHOOL 10
353 CONGRESS AVE
ROCHESTER, NEW YORK 14619

SED Control No. 26-16-00-01-0-037-021

Key Plan

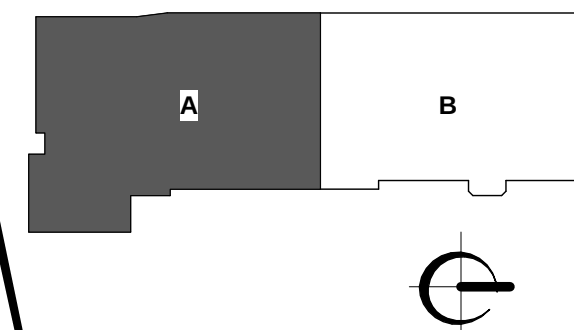

SEI
design group

585.442.7010 • 224 MB St. • Rochester, NY 14614
518.435.2467 • 187 Wolf Rd., Suite 304 • Albany, NY 12205
607.304.4350 • 2 Court St., Suite 404 • Binghamton, NY 13901

It is a violation of Title VII, Article 547 of NY Education Law for any person,
other than under the direction of a licensed architect, to alter any plans or
specifications in any way. Any person who alters this document is required
by law to affix his or her name and the location where the alteration is made to the
original drawing and a separate description of the alteration made.

BID DOCUMENTS

Date 12/13/2018 SEI Project No. 17-3016

Revisions

1 01/11/19 ADDENDUM

FURNITURE PLAN -
FIRST FLOOR AREA A
& LOWER LEVEL

A1800

GENERAL NOTE:
THE FURNITURE WILL BE FURNISHED BY OTHERS AND THE INTENT
OF THIS DRAWING IS FOR COORDINATION PURPOSES ONLY.

ROCHESTER CITY
SCHOOL DISTRICT



Every child is a work of art.
Create a masterpiece.

DR. WALTER COOPER

SCHOOL 10

353 CONGRESS AVE.
ROCHESTER, NEW YORK 14619

SED Control No. 26-16-00-01-0-037-021


Key Plan



SEI
design group

585.442.7010 • 224 MB St. • Rochester, NY 14614
518.435.2467 • 187 Wolf Rd., Suite 304 • Albany, NY 12205
607.304.4550 • 2 Court St., Suite 404 • Binghamton, NY 13901

ENGAGE • IMAGINE • INSPIRE

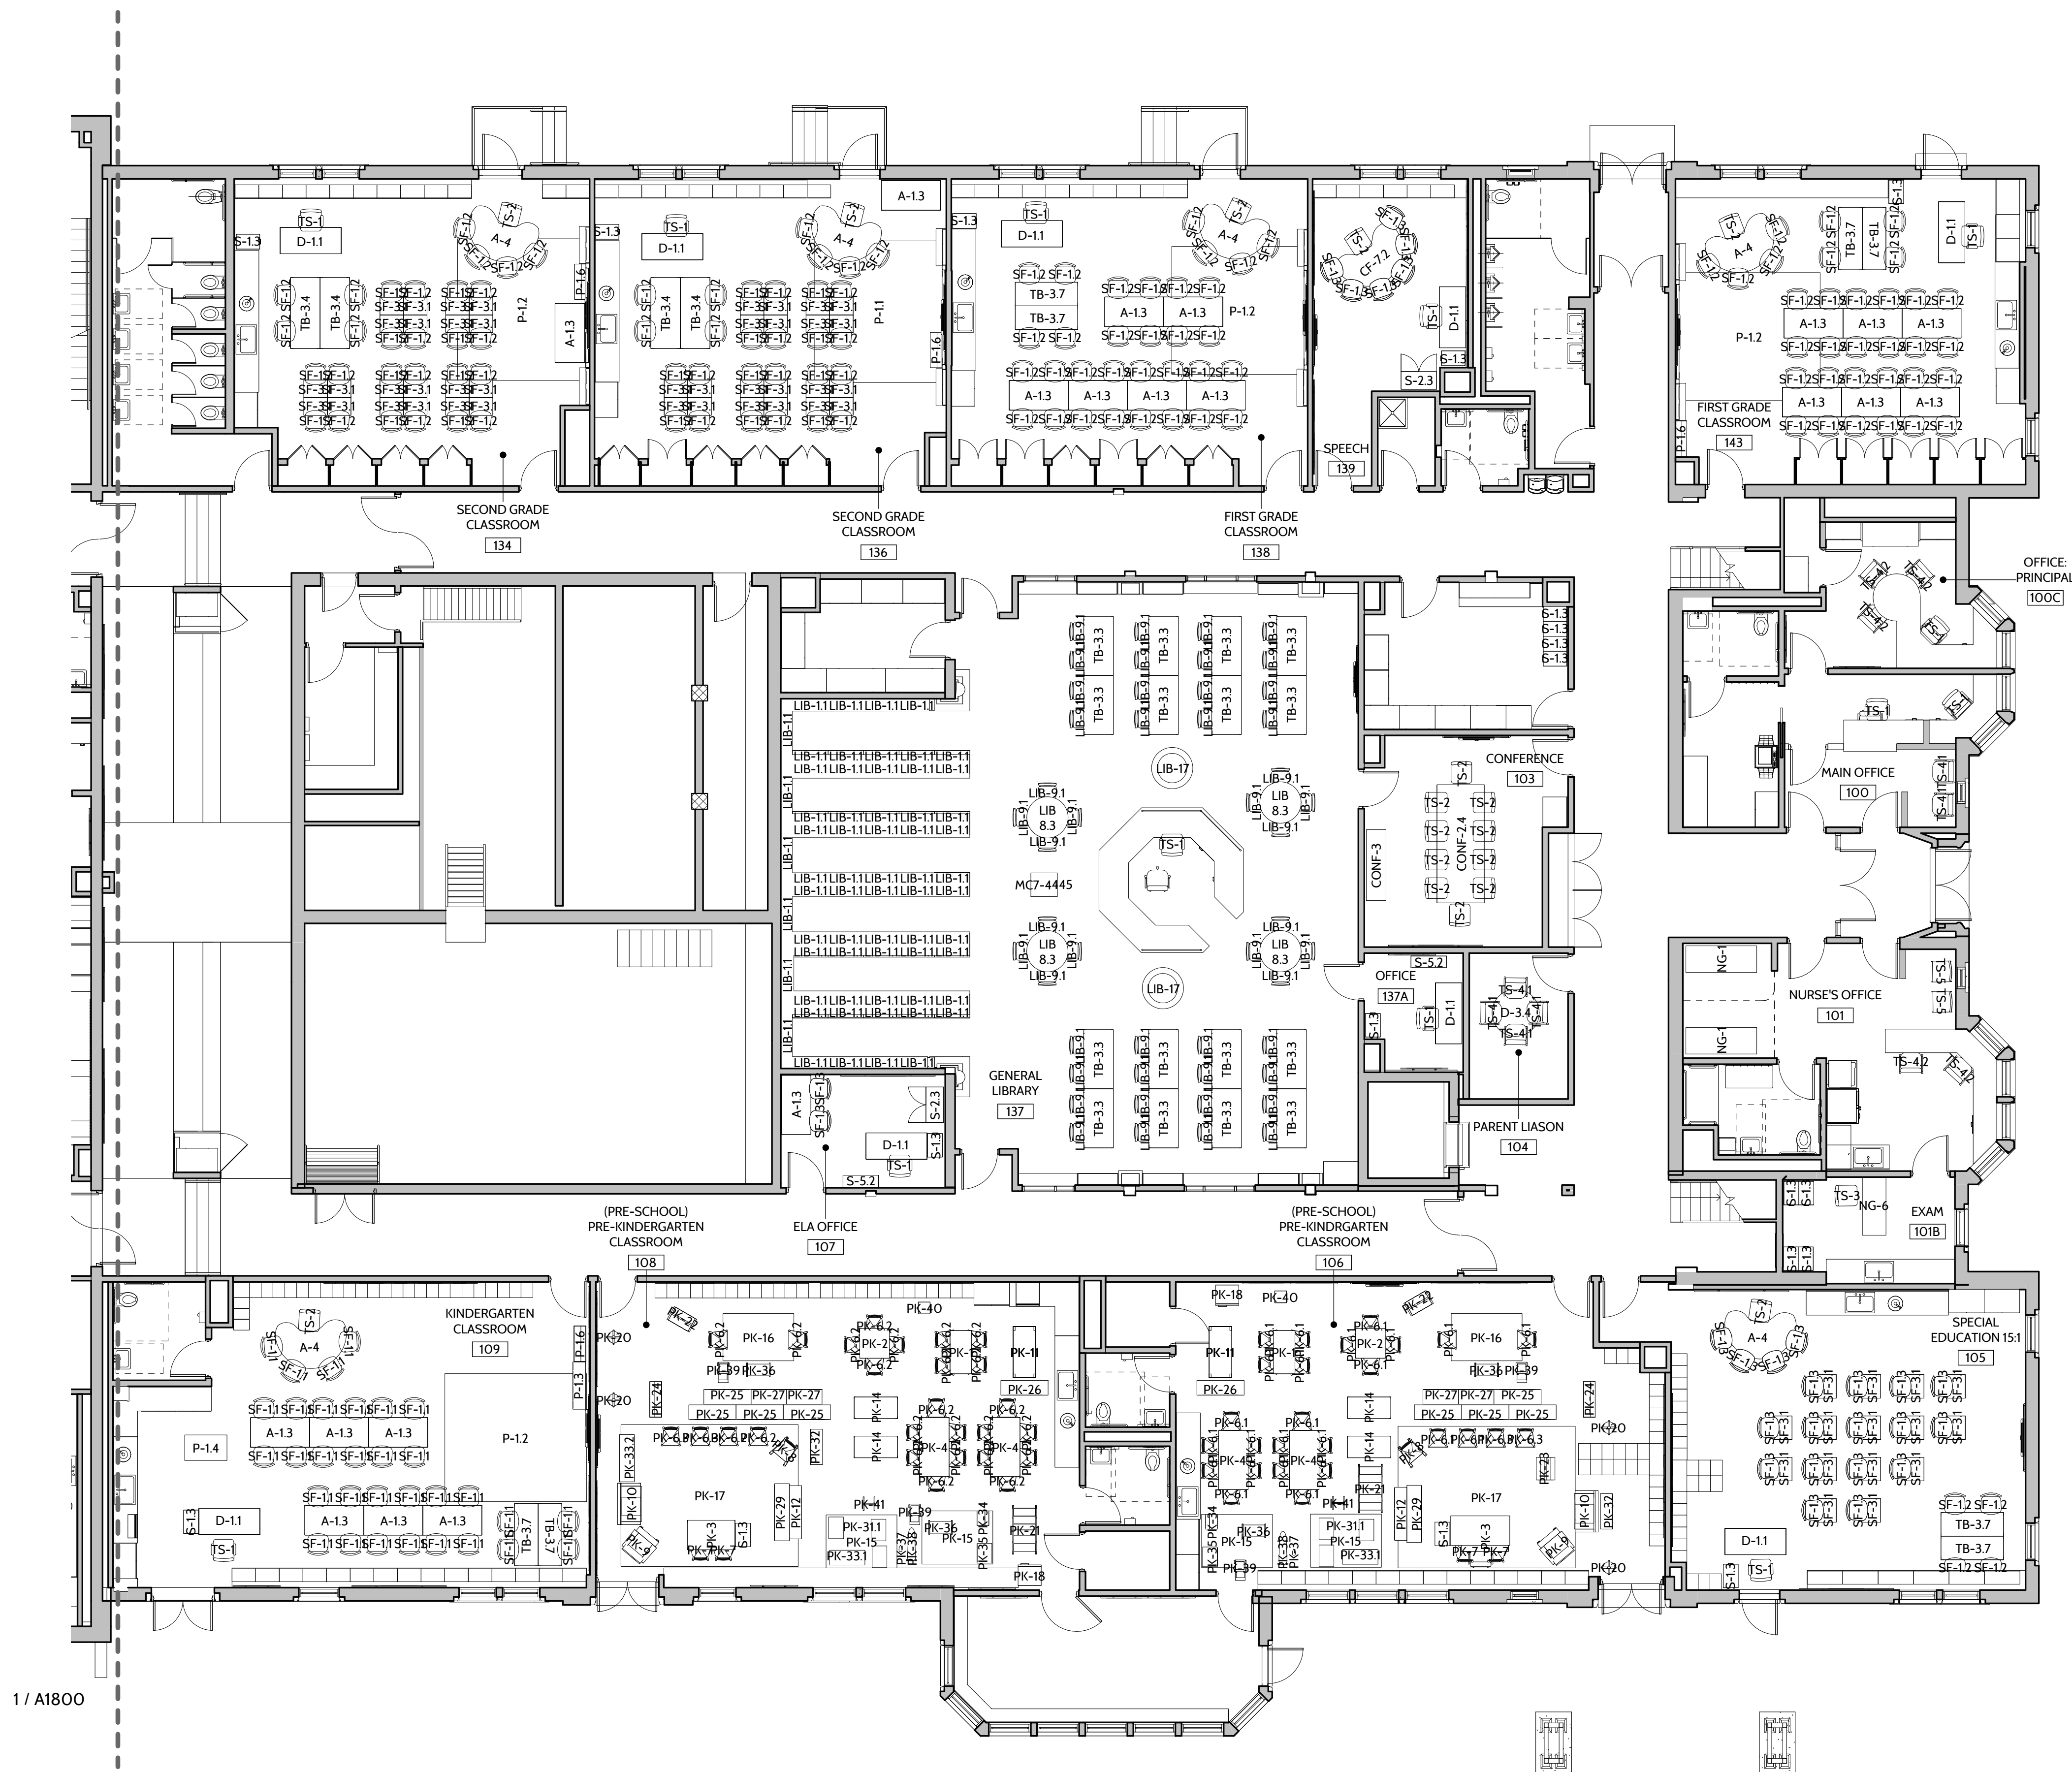

1 FIRST FLOOR FURNITURE PLAN - AREA A
1/8" = 1'-0"

It is a violation of Title VII, Article 54 of NY Education Law for any person, unless acting under the direction of a licensed architect, to alter any room or building without the approval of the Board of Education. Any person who alters this document is required by law to affix his or her name and the notation "altered by" followed by his or her signature and a complete description of the alteration made.

BID DOCUMENTS

Date 12/13/2018 SEI Project No. 17-3016

Revisions


1 01/11/19 ADDENDUM

FURNITURE PLAN -
FIRST FLOOR AREA B

A1801

SED Control No. 26-16-00-01-0-037-02

Key Plan

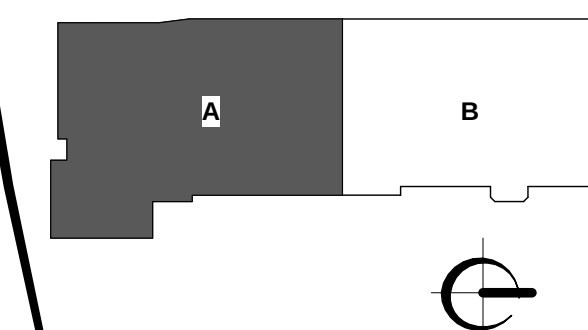

SEI
design group

585.442.7010 - 224 Mill St. - Rochester, NY 146
518.435.2467 - 187 Wolf Rd., Suite 304 - Albany, NY 122
607.304.4550 - 2 Court St., Suite 404 - Binghamton, NY 139

It is a violation of Title VIII, Article 167 of NYS Education Law for any person, unless acting under the direction of a licensed architect, to alter any item on this document in any way. Any licensee who alters this document is required by law to affix his or her seal and the notation "altered by" followed by his or her name.


Date **12/13/2018** SEI Project No. **17-301**

Revisions

1	01/11/19	ADDENDUM
---	----------	----------

A1802

GENERAL NOTE:
THE FURNITURE WILL BE FURNISHED BY OTHERS AND THE INTENT
OF THIS DRAWING IS FOR COORDINATION PURPOSES ONLY.

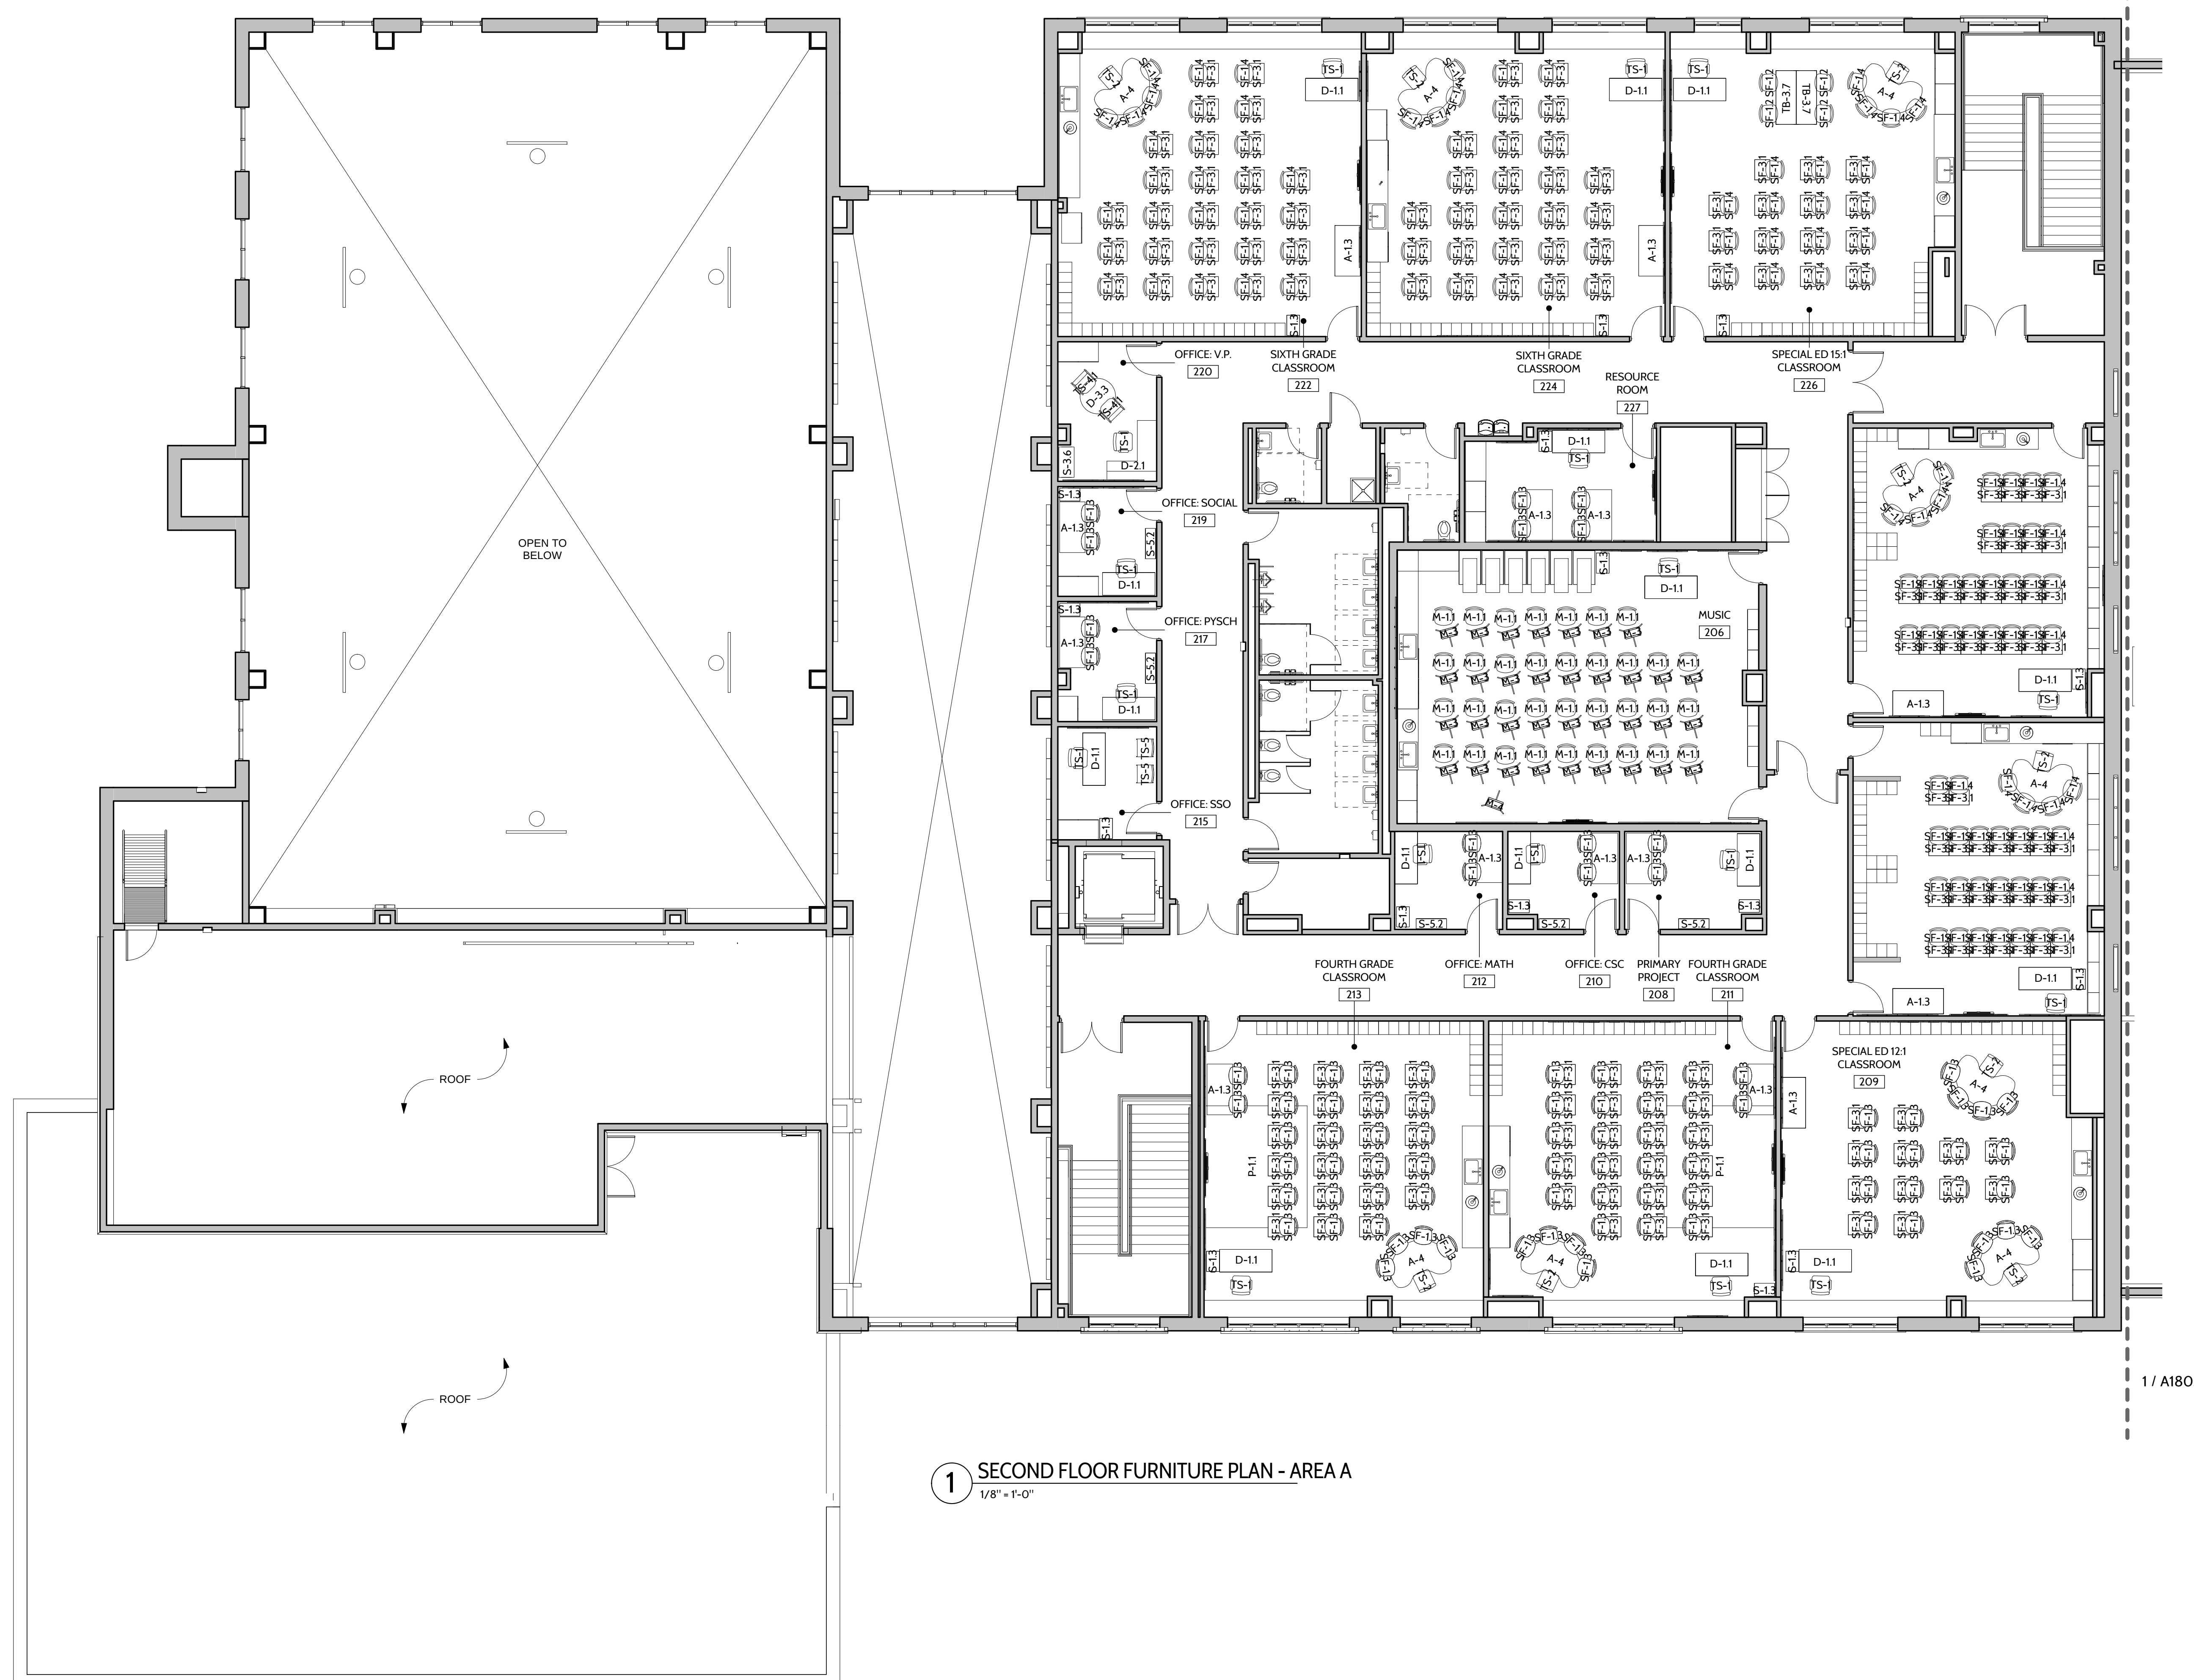


1 SECOND FLOOR FURNITURE PLAN - AREA A
1/8" = 1'-0"

1 / A180

SED Control No. 26-16-00-01-0-037-021

Key Plan

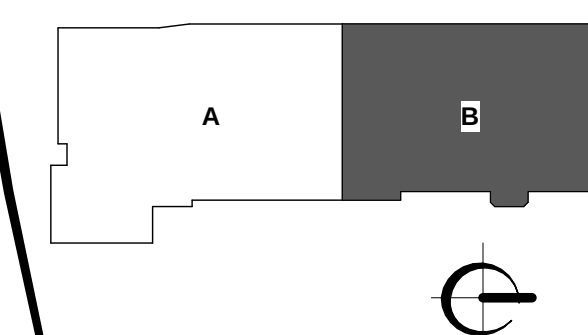

SEI
design group

585.442.7010 - 224 Mill St. - Rochester, NY 14614
518.435.2467 - 187 Wolf Rd., Suite 304 - Albany, NY 12205
607.304.4550 - 2 Court St., Suite 404 - Binghamton, NY 13901

It is a violation of Title VIII, Article 147 of NYS Education Law for any person, unless acting under the direction of a licensed architect, to alter any item on this document in any way. Any licensee who alters this document is required by law to affix his or her seal and the notation "altered by" followed by his or her signature and date of alteration, above, above the mark.


Date 12/13/2018 SEI Project No. 17-3016

Revisions



1	01/11/19	ADDENDUM
---	----------	----------

A1803


GENERAL NOTE:
THE FURNITURE WILL BE FURNISHED BY OTHERS AND THE INTENT
OF THIS DRAWING IS FOR COORDINATION PURPOSES ONLY.

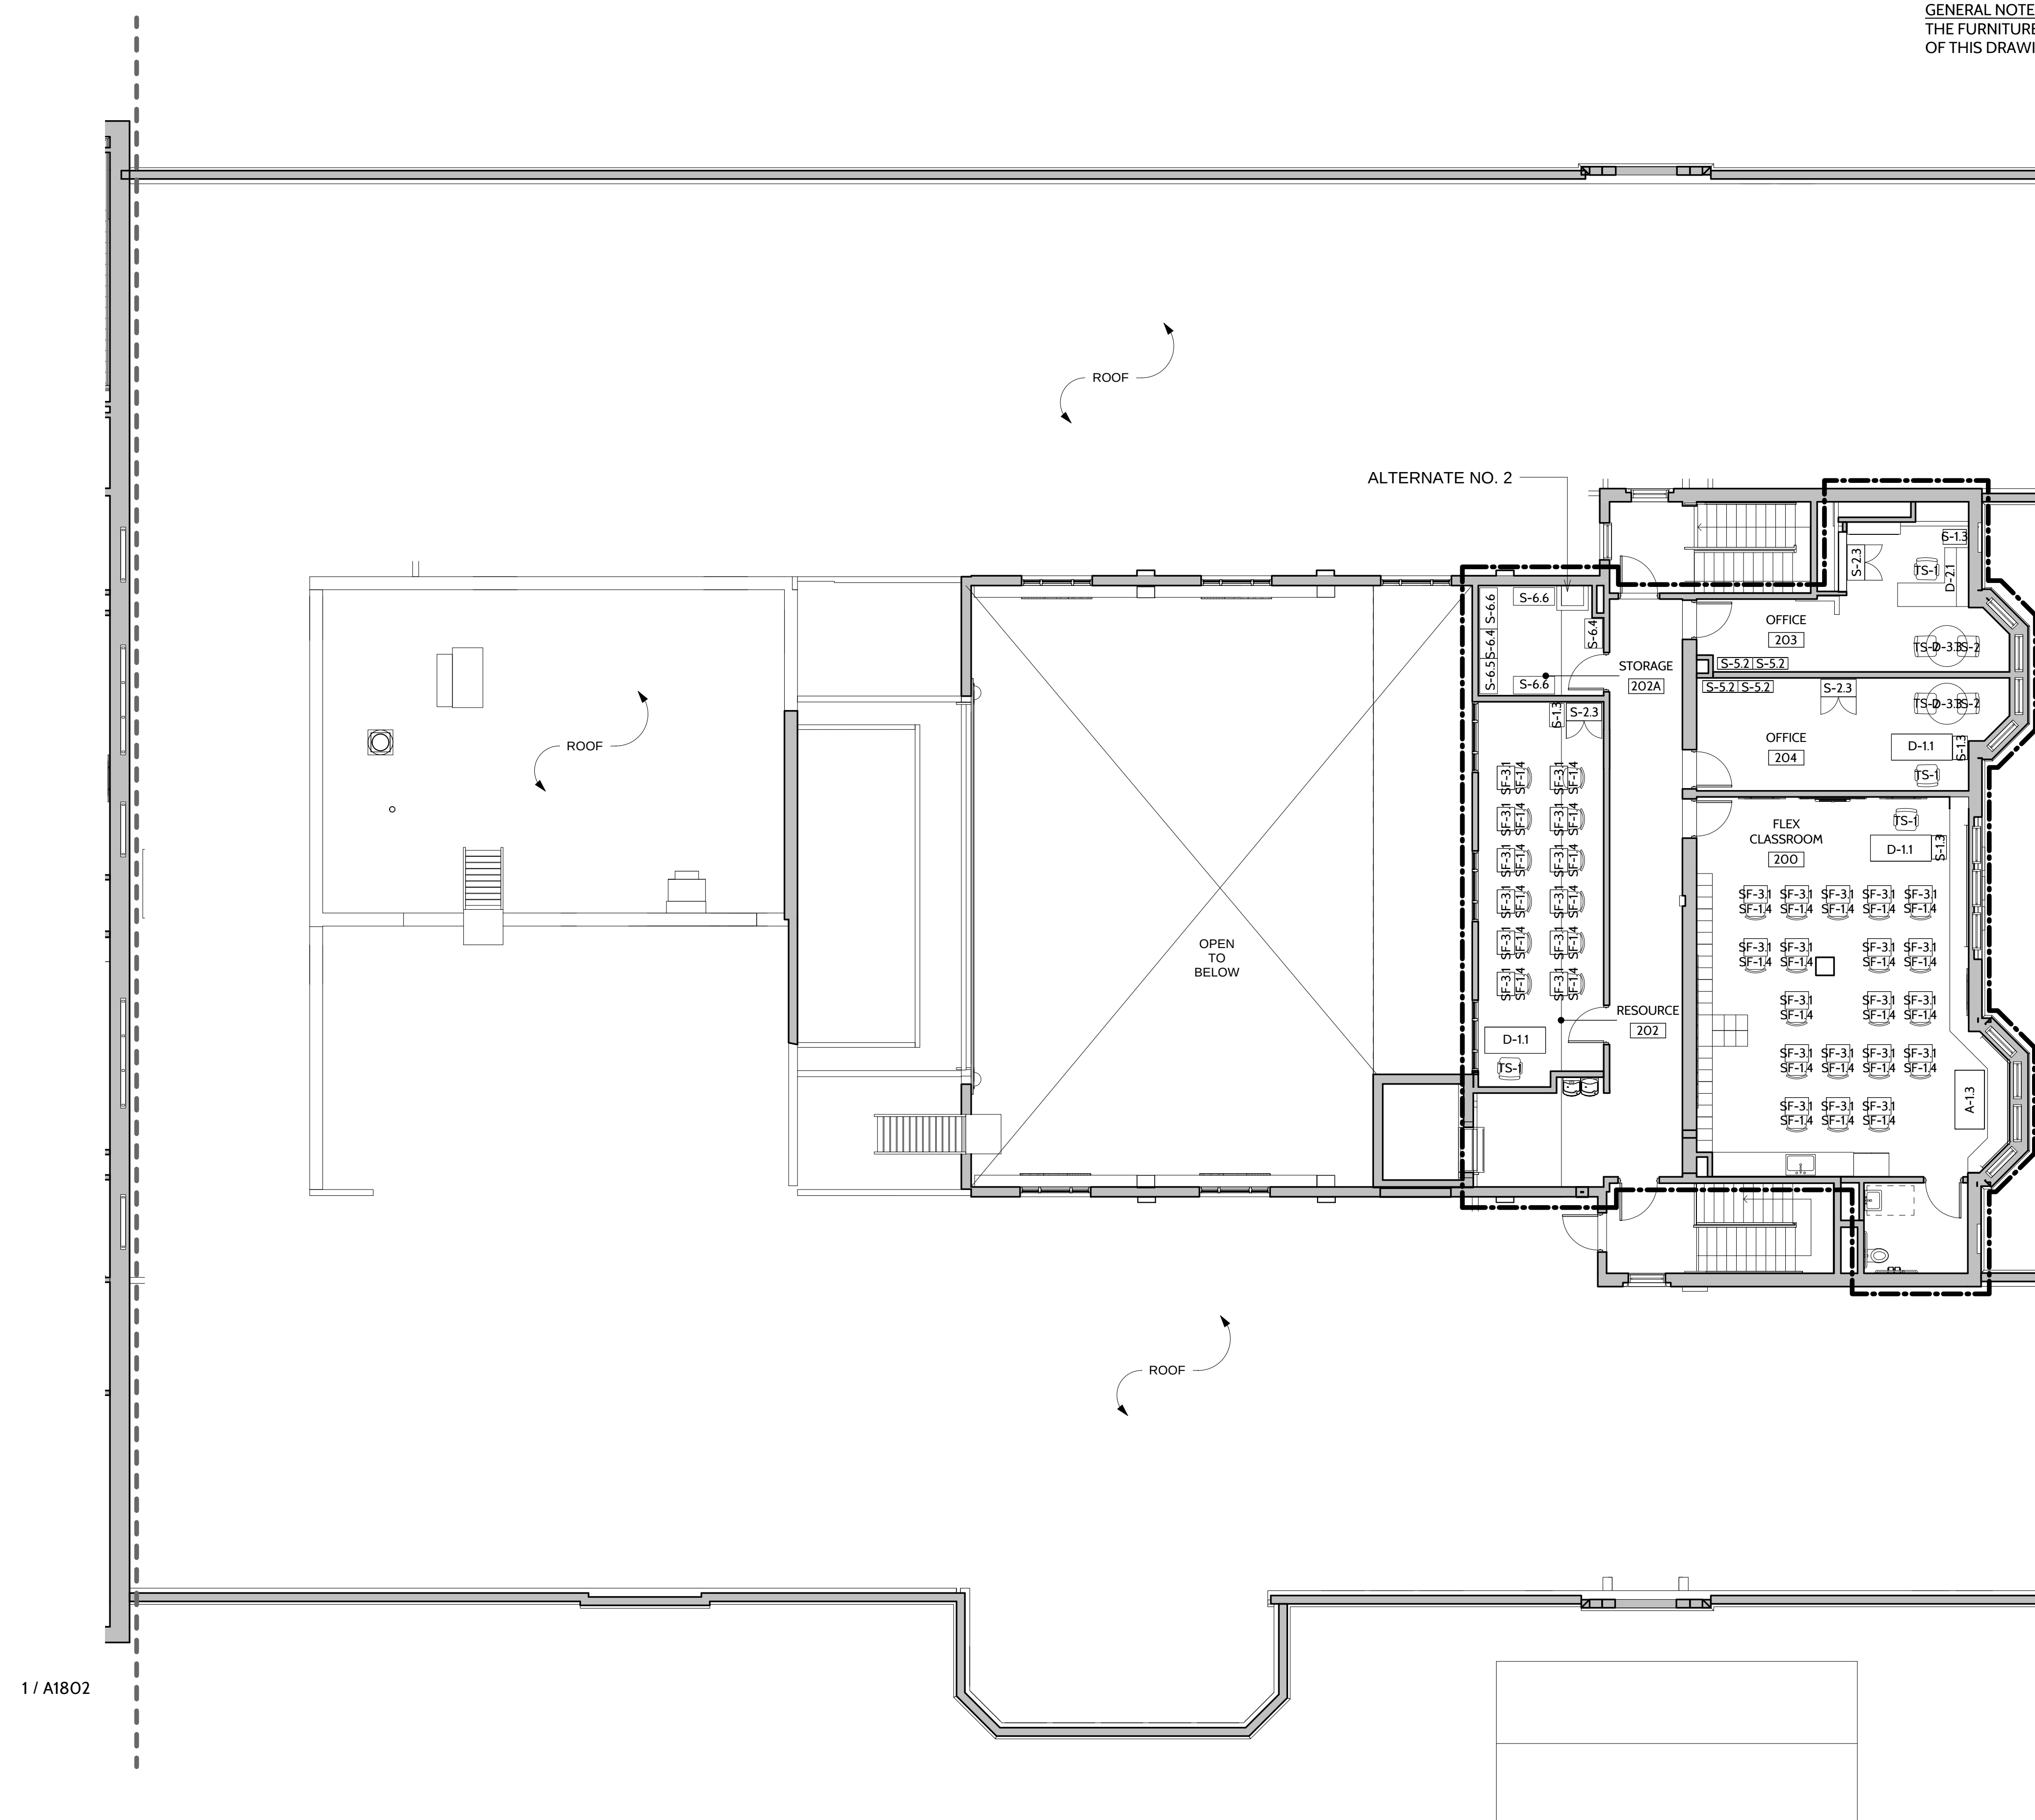

1 SECOND FLOOR FURNITURE PLAN - AREA B
1/8" = 1'-0"

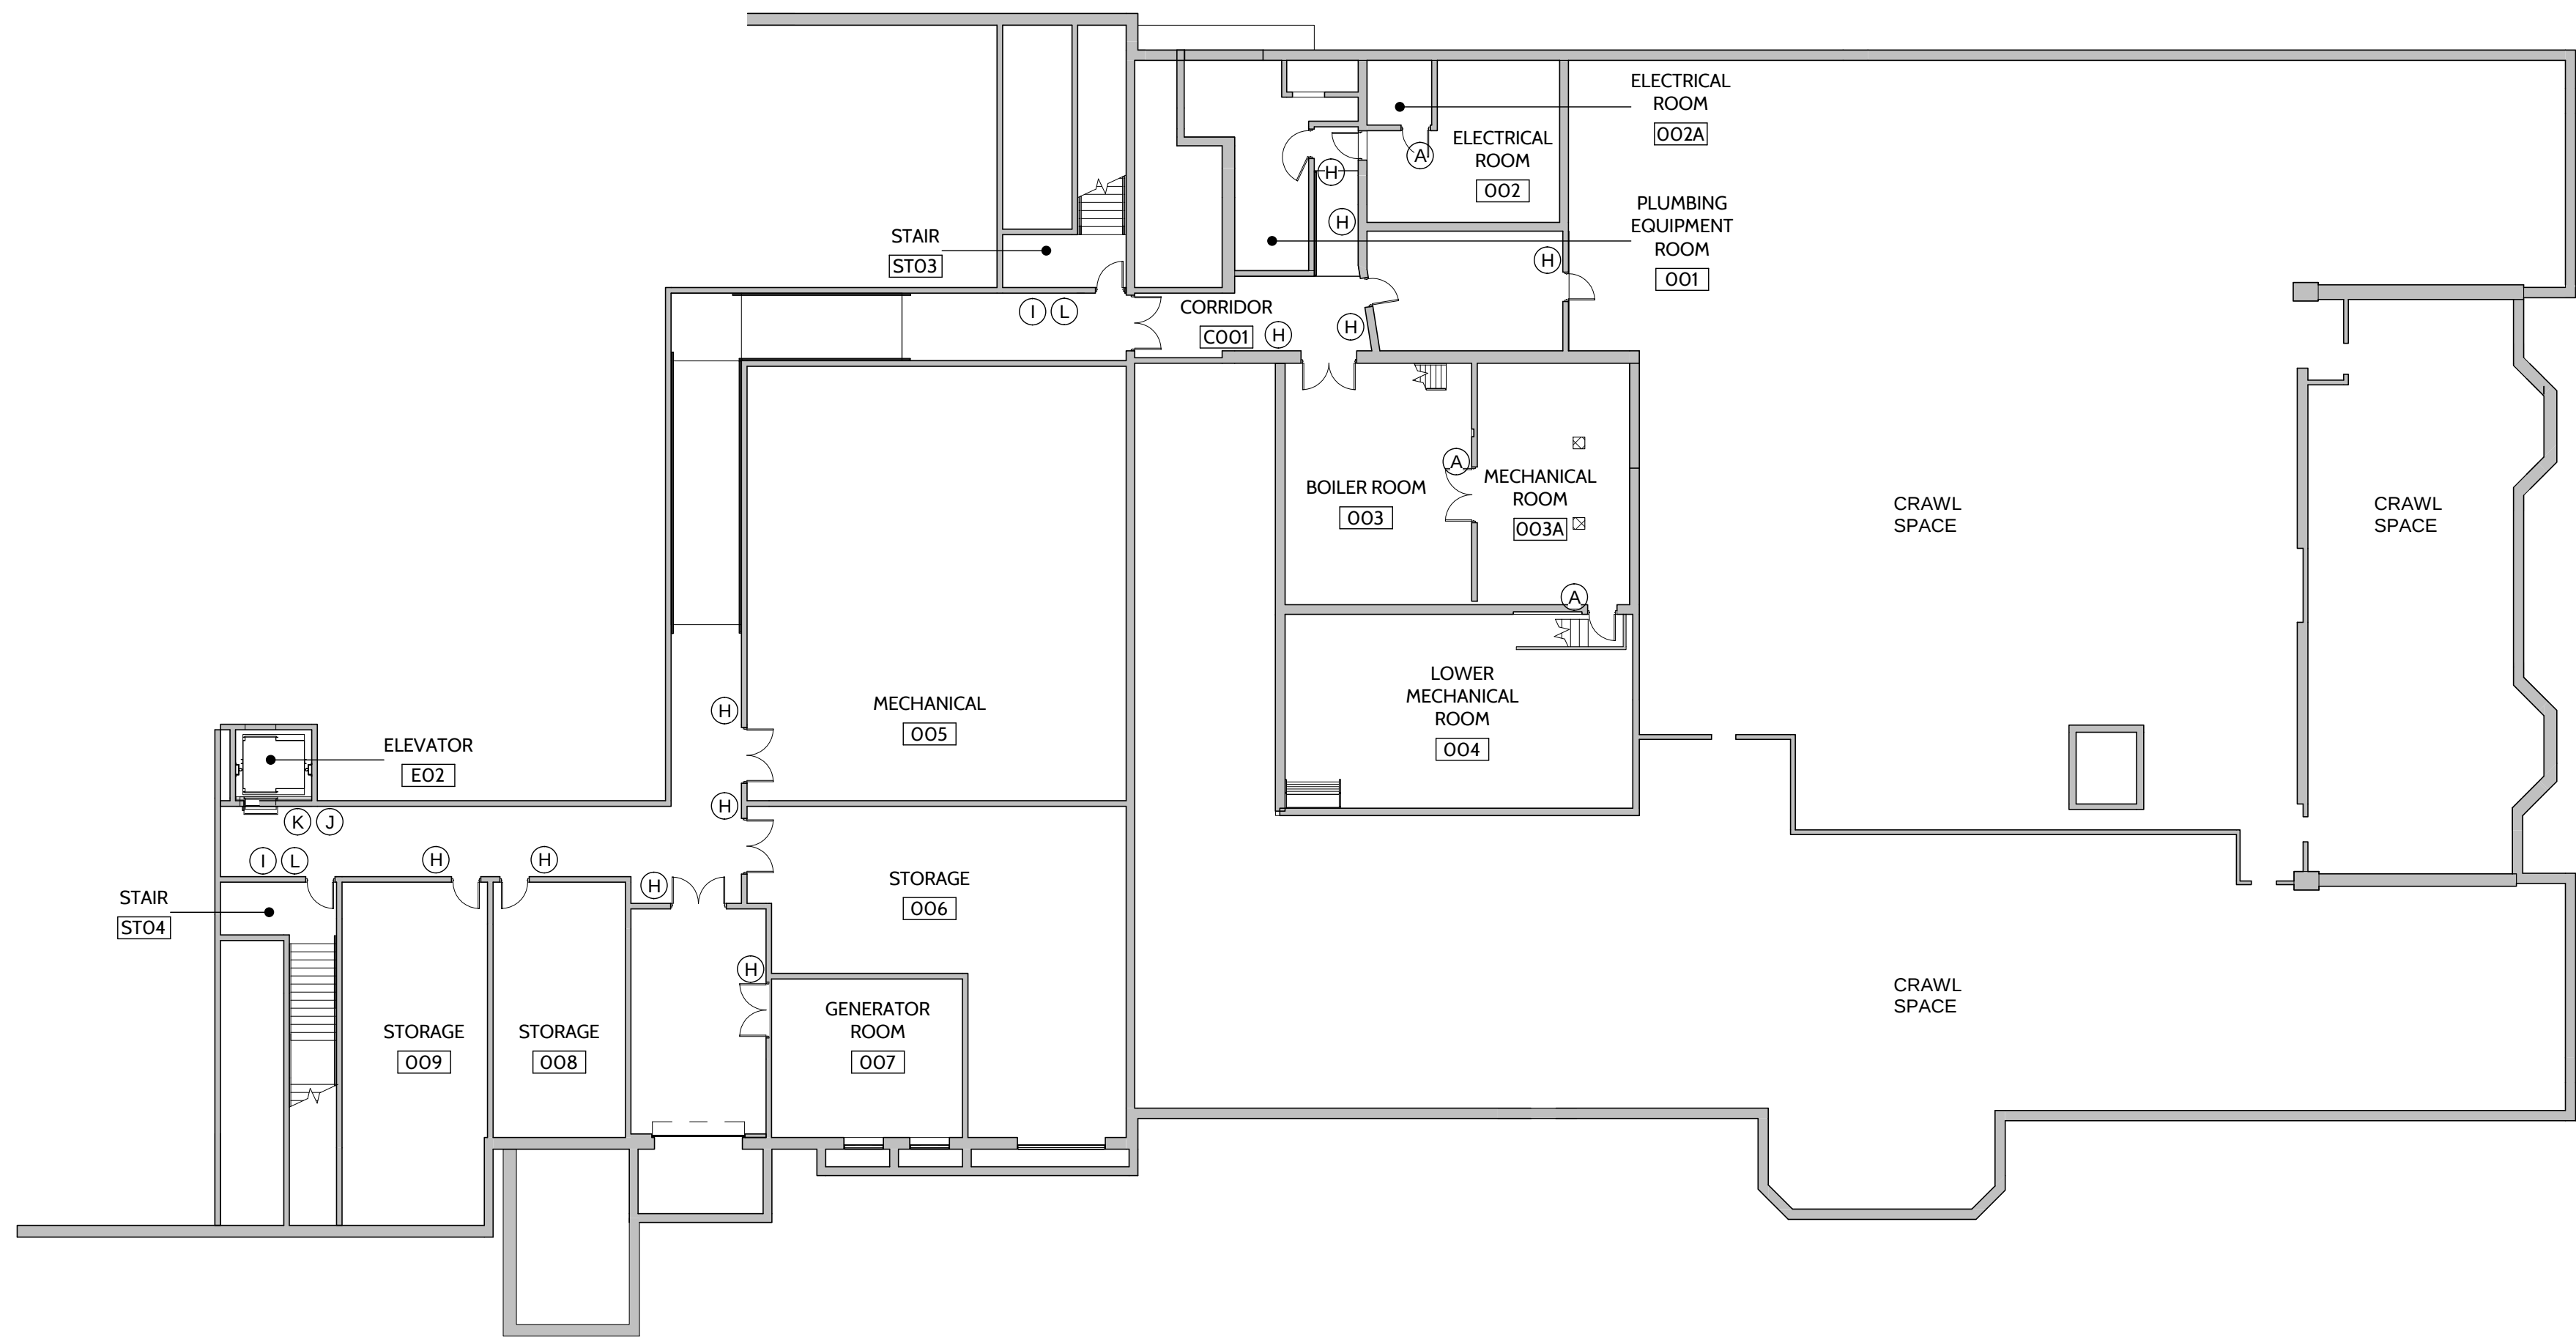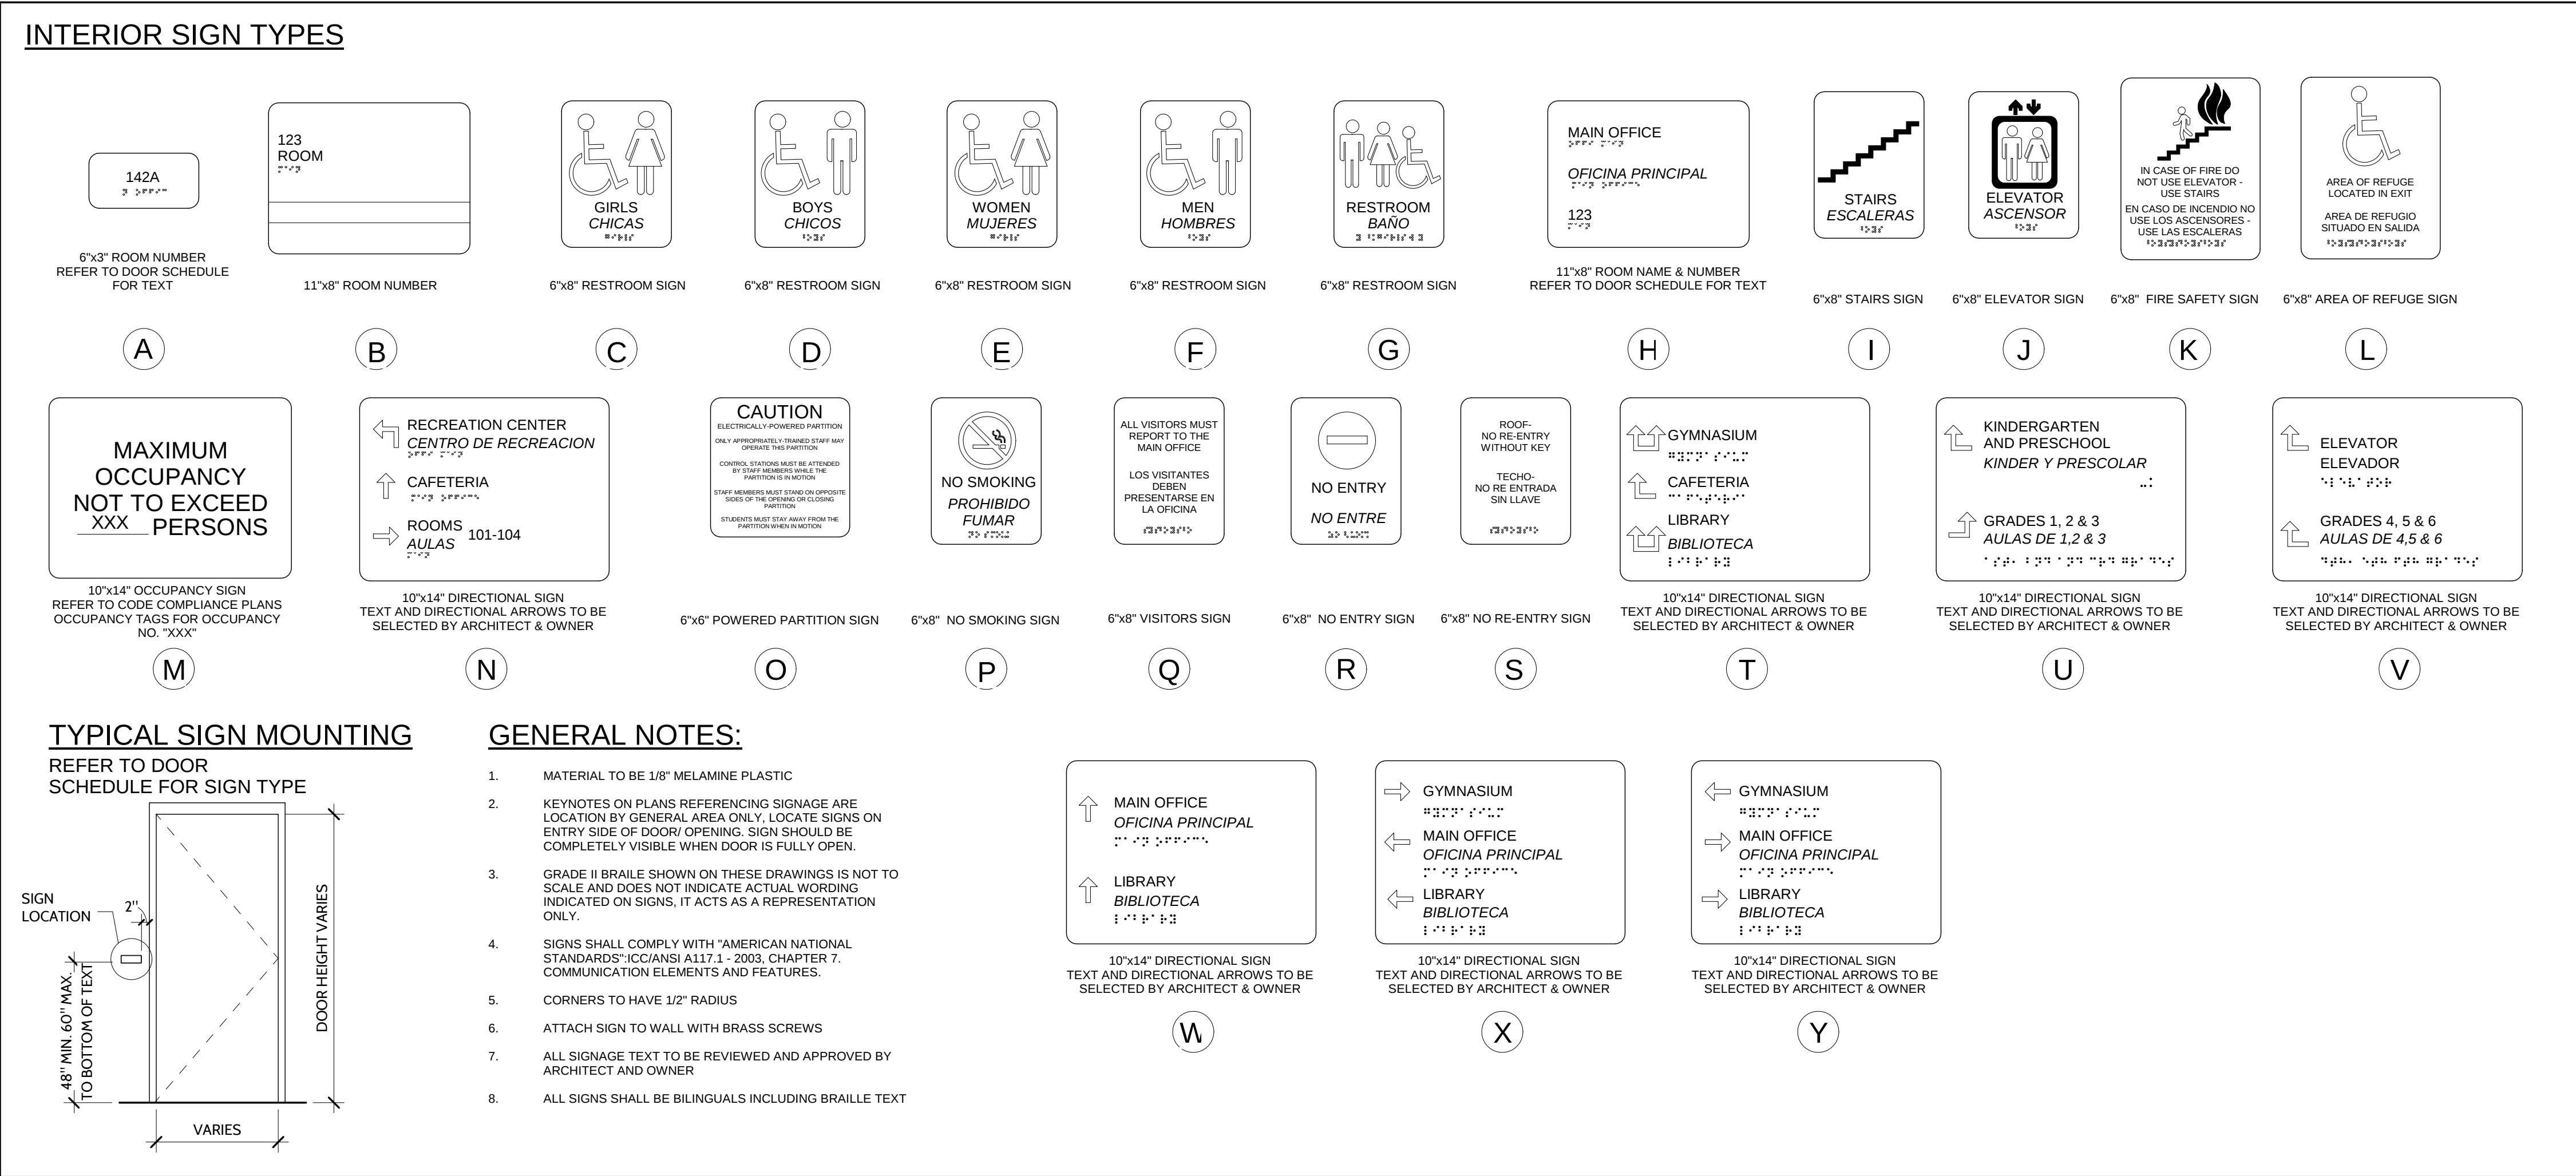

1 LOWER LEVEL SIGNAGE
1/16" = 1'-0"

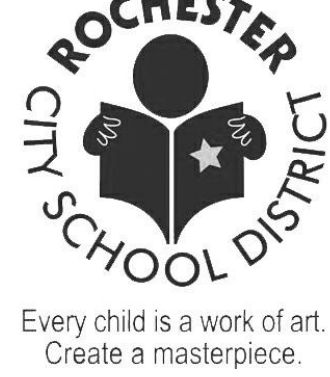


Every child is a work of art.
Create a masterpiece.

DR. WALTER COOPER

SCHOOL 10
353 CONGRESS AVE
ROCHESTER, NEW YORK 14619

SED Control No. 26-16-00-01-0-037-021

Key Plan

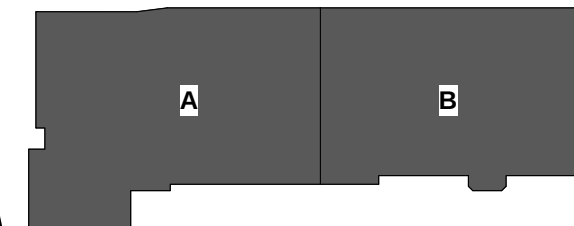

SEI
design group

585.442.7010 - 224 MBI St. - Rochester, NY 14614
518.435.2467 - 187 Wolf Rd., Suite 304 - Albany, NY 12205
607.304.4550 - 2 Court St., Suite 404 - Binghamton, NY 13901

It is a violation of New York Education Law for any person, unless acting under the direction of a licensed architect, to alter any plan and the documents in any way. Any person who alters this document is required by law to affix his or her name and the notation "altered by" followed by his or her signature and a complete description of the alteration made.

BID DOCUMENTS


Date **12/13/2018** SEI Project No. **17-3016**
Revisions
1 01/11/19 ADDENDUM

**SIGNAGE PLAN -
LOWER LEVEL**

A1900

SCHOOL 10
353 CONGRESS AVE.
ROCHESTER, NEW YORK 14619

Key Plan

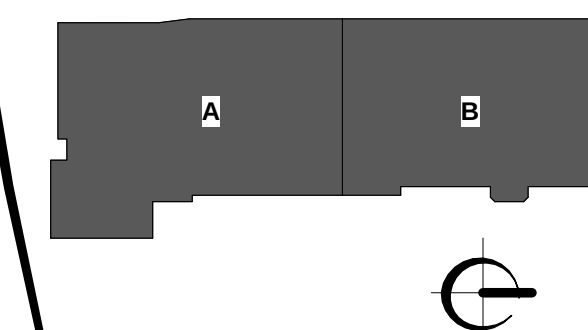

SEI
design group

585.442.7010 - 224 Mill St. - Rochester, NY 146
518.435.2467 - 187 Wolf Rd., Suite 304 - Albany, NY 122
607.304.4550 - 2 Court St., Suite 404 - Binghamton, NY 139

This detailed floor plan illustrates the second floor of a school building, organized into three main sections. The left section features a large 'OPEN TO BELOW' area and a 'STAIR ST04'. The middle section contains a central corridor with various support spaces including an 'OFFICE: VP', 'OFFICE: SOCIAL', 'OFFICE: PSYCH', 'OFFICE: SSO', 'ELEVATOR E02', 'TOILET 221', 'RESOURCE ROOM 227', 'BOYS TOILET 218', 'GIRLS TOILET 216', 'MUSIC 206', 'OFFICE: CSC 210', 'DATA 214', 'OPEN OFFICE MATH 212', 'PRIMARY PROJECT 208', and 'STAIR ST03'. The right section includes 'FIFTH GRADE CLASSROOM' (205, 207), 'SIXTH GRADE CLASSROOM' (222, 224), 'SPECIAL EDUCATION 15:1 CLASSROOM' (226), 'FOURTH GRADE CLASSROOM' (213, 211), 'SPECIAL ED 12:1 CLASSROOM' (209), 'STAIR ST02', 'TOILET 200A', 'OFFICE 203', 'OFFICE 204', 'FLEX CLASSROOM 200', 'RESOURCE 202', 'STORAGE 202A', and 'ELEVATOR E01'. Numerous rooms are marked with letters (A, B, C, D, G, H, I, J, K, L) and numbers (1, 2, 3, 4, 99, 100) indicating specific locations or zones. The plan also shows 'ROOF' areas and 'OPEN TO BELOW' spaces.

The floor plan illustrates the second floor of a school building, featuring a variety of educational and administrative spaces. Key areas include:

- Classrooms:** First Grade (138, 143), Second Grade (134, 136), Third Grade (127, 129), Kindergarten (111, 109), Pre-Kindergarten (108, 106), and Special Education (121, 113, 105).
- Support Spaces:** Gym (122), Cafeteria (119), Kitchen (120), Office P.E. (122C), Office Custodial (115A), Office Principal (100C), Main Office (100), Nurse's Office (101), and Exam (101B).
- Administrative & Professional:** Professional Development (116), Reading Suite (126), Speech (Related Service) (126A, 112), and various other offices and service rooms.
- Recreation & Activity:** Maker Room (110), Kiln (110A), and a large open area for general library (137) and resource (103) activities.
- Restrooms & Storage:** Multiple restrooms for boys and girls, and numerous storage rooms throughout the building.
- Corridors & Stairs:** A network of corridors (e.g., C102B, C103, C104) and stairwells (e.g., ST01, ST02, ST03, ST04) connecting the various rooms.

The plan is detailed with room numbers, letters, and symbols indicating furniture, doors, and other architectural features.

It is a violation of Title VII, Article 147 of NYS Education Law for any person, unless acting under the direction of a licensed architect, to alter any item on this document in any way. Any licensee who alters this document is required by law to affix his or her seal and the notation "altered by" followed by his or her name.

Date 12/13/2018 SEI Project No. 17-301

Revisions

1 01/11/19 ADDENDUM

SIGNAGE PLAN FIRST AND SECOND FLOOR

A1901



Every child is a work of art.
Create a masterpiece.

DR. WALTER COOPER

SCHOOL 10
353 CONGRESS AVE
ROCHESTER, NEW YORK 14619

SED Control No. 26-16-00-01-0-037-021

Key Plan



SEI
design group

585.442.7010 • 224 Mill St. • Rochester, NY 14614
518.435.2467 • 187 Wolf Rd., Suite 304 • Albany, NY 12205
607.304.4550 • 2 Court St., Suite 404 • Binghamton, NY 13901

It is a violation of Title VII, Article 147 of NYS Education Law for any person, under acting under the direction of a licensed architect to alter any plan and the documents in any way. Any person who alters this document is required by law to affix his or her name and the notation "altered by" followed by his or her signature and a complete description of the alteration made.

BID DOCUMENTS

Date 12/13/2018 SEI Project No. 17-3016

Revisions

1 01/11/19 ADDENDUM

SIGNAGE SCHEDULE

A1902

SIGNAGE SCHEDULE

Room Name	Sign Number	Sign Type	Copy Line 1	Copy Line 2	Remarks
PLUMBING EQUIPMENT ROOM	001	H	PLUMBING EQUIPMENT ROOM	001	
ELECTRICAL ROOM	002	H	ELECTRICAL ROOM	002	
ELECTRICAL ROOM	002A	A	002A		
BOILER ROOM	003	H	BOILER ROOM	003	
UPPER BOILER ROOM	003	A	003		
MECHANICAL ROOM	003A	A	003A		
LOWER MECHANICAL ROOM	004	A	004		
UPPER FAN ROOM	004	H	FAN ROOM	004	
MECHANICAL	005	H	MECHANICAL ROOM	005	
STORAGE	006	H	STORAGE	006	
GENERATOR ROOM	007	H	GENERATOR ROOM	007	
STORAGE	008	H	STORAGE	008	
STORAGE	009	H	STORAGE	009	
MAIN OFFICE	100	H	100	MAIN OFFICE	
COPPER	100A	A			
TOILET	100B	G			
STORAGE	100B	A	110B		
OFFICE, PRINCIPAL	100C	H	PRINCIPAL'S OFFICE	100C	
NURSE'S OFFICE	101	H	NURSE'S OFFICE	101	
TOILET	101A	G			
EXAM	101B	H	EXAM ROOM	101B	
WORK ROOM	102, 102.1	H, H	WORK ROOM	102	BOTH DOORS TO THE ROOM GET A SIGN
CONFERENCE	103, 103.1	H, H	CONFERENCE ROOM	103	BOTH DOORS TO THE ROOM GET A SIGN
PARENT LIASON	104	H	PARENT LIASON ROOM	104	
SPECIAL EDUCATION 15.1	105	B	118		
(PRE-SCHOOL) PRE-KINDERGARTEN CLASSROOM	106, 106.1	B, B	106		BOTH DOORS TO THE ROOM GET A SIGN
TOILET	106A	G			
STORAGE	106B	A	106B		
ELA OFFICE	107	A	107		
(PRE-SCHOOL) PRE-KINDERGARTEN CLASSROOM	108	B, B	108		BOTH DOORS TO THE ROOM GET A SIGN
TOILET	108A	G			
STORAGE	108B	A	108B		
KINDERGARTEN CLASSROOM	109	B	109		
TOILET	109A	G			
MAKER SPACE	110	B	ART	110	
KILN	110A	A	110A		
KINDERGARTEN CLASSROOM	111	B	111		
TOILET	111A	G			
READING	112	B	112		
SPECIAL EDUCATION 12.1.1	113	B	113		
OT/PT	114	B	114		
RECEIVING	115	H	RECEIVING	115	
OFFICE, CUSTODIAL	115A	A	115A		
TOILET ROOM	115B	G			
TEACHER LOUNGE	116	B	116		
TOILET	117	G			
TOILET	118	G			
CAFETERIA	119, 119.1	H, M	CAFETERIA	119	
TOILET	119A	G			
STORAGE	119B	A	119B		
KITCHEN	120	H	KITCHEN	120	
STORAGE	120A	A	120A		
OFFICE, KITCHEN	120B	A	120B		
J.C	120D	A	120D		
LOCKER ROOM	120E	A	120D		
TOILET	120F	G			
STORAGE	121	A	121		
GYM	122, 122.1, 122.2, 122.3	H, H, M, O	GYMNASIUM	122	BOTH DOORS TO THE ROOM GET A SIGN
STOR	122A	A	122A		
OFFICE, P.E.	122C	A	122C		
TOILET	122D	G			
STORAGE	122E	A	122E		
BOYS TOILET	123	D			
GIRL'S TOILET	124	C			
SPECIAL EDUCATION 12.1.1	125	B	125		
READING/SPEECH SUITE	126	B	126		
OFFICE, SPEECH	126A	A	126A		
OFFICE, SPEECH	126B	A	126B		
THIRD GRADE CLASSROOM	127	B	127		
ESOL CLASSROOM	128	B	128		
STORAGE	128A	A	128A		
THIRD GRADE CLASSROOM	129	B	129		
TOILET	130	G			
TOILET	131	G			
GIRL'S TOILET	132	C			
VESTIBULE	133	H	133 - DATA	003 - BOILER ROOM	
DATA	133A	A	133A		
SECOND GRADE CLASSROOM	134	B	134		
STORAGE	135	A	135		
SECOND GRADE CLASSROOM	136	B	136		
GENERAL LIBRARY	137, 137.1, 137.2	H, H, M	LIBRARY	137	BOTH DOORS TO THE ROOM GETS A SIGN
OFFICE	137A	A	137A		
STORAGE	137B	A	137B		
FIRST GRADE CLASSROOM	138	B	138		
SPEECH	139	B	139		
J.C	140	A	140		
TOILET	141	C			
BOYS TOILET	142	D			
FIRST GRADE CLASSROOM	143	B	143		
FLEX CLASSROOM	200	B	200		
TOILET	200A	G			
RESOURCE	202	B	202		
STORAGE	202A	A	202A		
OFFICE	203	A	203		
OFFICE	204	A	204		
FIFTH GRADE CLASSROOM	205	B	205		
MUSIC	206	B	MUSIC	206	
FIFTH GRADE CLASSROOM	207	B	207		
PRIMARY PROJECT	208	B			
SPECIAL ED 12.1 CLASSROOM	209	B	209		
OFFICE, CSC	210	A	210		
FOURTH GRADE CLASSROOM	211	B	211		
OFFICE, MATH	212	H	MATH ROOM	212	
FOURTH GRADE CLASSROOM	213	B	213		
DATA	214	H	DATA ROOM	214	
OFFICE, SSO	215	H	SSO	C104	
GIRL'S TOILET	216	C			
OFFICE, PYSCH	217	A	PSYCHOLOGIST	217	
BOYS TOILET	218	D			
OFFICE, SOCIAL	219	A	SOCIAL WORKER	219	
OFFICE, V.P.	220	H	VICE PRINCIPAL	220	
TOILET	221	G			
SIXTH GRADE CLASSROOM	222	B	222		
TOILET	223	G			
SIXTH GRADE CLASSROOM	224	B			
J.C	225	H	JANITOR	225	
SPECIAL ED 15.1 CLASSROOM	226	B	226		
RESOURCE ROOM	227	B	227		
ELEVATOR	E01, E01.1	J, K			J SIGN ABOVE K SIGN
ELEVATOR	E01.2, E01.3	J, K			J SIGN ABOVE K SIGN
ELEVATOR	E02, E02.1	J, K			J SIGN ABOVE K SIGN
ELEVATOR	E02.2, E02.3	J, K			J SIGN ABOVE K SIGN
ELEVATOR	E02.4, E02.5	J + K			J SIGN ABOVE K SIGN
STAIR	ST01	I			
STAIR	ST01	I			
STAIR	ST02	I			
STAIR	ST02	I			
STAIR	ST03	I + L			
STAIR	ST03, ST03.1	I, L			
STAIR	ST03.2, ST03.3	I, L			
STAIR	ST04	I + L			
STAIR	ST04, ST04.1	I, L			
STAIR	ST04.2, ST04.3	I, L			



This document is not an official part of the construction documents and is being provided to the bidders for information purposes only.

RFI #	Date	Company	Question	Responded by:	Answer
1	2-Jan-19	DCI	Can Ardex V1200 be used in lieu of the Ardex SDP at the areas requiring ¼" minimum underlayment? Ardex V1200 is a self-leveling/flowable product whereas the Ardex SDP is a troweled application. Please clarify the intent for the moisture control system listed in specification section 035416. Should the basis of design, Ardex MC Rapid be included in the base bid in all areas to receive floor covering.	SEI	Refer to RFI # 3 response.
2	2-Jan-19	Apex Window Films	I see your company had drawn up the plans for the Rochester School #10 project. I was asked to quote the filming in the project and saw three films types in the spec. However I did not see anything in the drawings or alternatives section calling out the films? Could you possibly help or direct me to the person in charge of this particular project so I could pose the question? I appreciate your business and any help you can provide.	SEI	Refer to sheet A1231 for the location of decorative window film. Refer to addendum # 2, item 2-10 and item 2-11 for revisions to the glazing film specification.
3	2-Jan-19	Manning Squires Hennig Co. Inc	1. Please provide clarification for spec section 035416 Hydraulic Cement Underlayment: Can Ardex V1200 be used in lieu of the Ardex SDP at the areas requiring 1/4" minimum underlayment? Ardex V1200 is a self-leveling/flowable product whereas the Ardex SDP is a troweled application. 2. Please clarify the intent for the moisture control system listed in specification section 035416. Should the basis of design, Ardex MC Rapid be included in the base bid in all areas to receive floor covering?	SEI	1. Refer to addendum # 2, item 2-1 and item 2-2 for revisions to the hydraulic cement underlayment specification. 2. No, provide a unit cost. Refer to addendum # 1, item 1-4 and item 1-5 for additional information.
4	7-Jan-19	Manning Squires Hennig Co. Inc	Please clarify if any moisture control system should be carried in the general contractor's base bid. We interpret UC-10 will only be utilized if the concrete slabs exceed the manufacturers allowable relative humidity and this price would be an add to our base bid contract. Please confirm if this is the intent.	SEI	Moisture mitigation is not a part of the projects base scope and it will only be added (via change order) when the relative humidity of the concrete exceeds the flooring manufacturer's allowable relative humidity. This does not relieve the general contractor from providing a permanent enclosure by the date listed in the project manual. In addition, the owner will enlist a third party to sample the concrete at strategic intervals in order to verify that the relative humidity of the concrete is lowering.
5	7-Jan-19	Apex Window Films	I see the three films mentioned in the specs. Looked at all drawings did not see any window films called out on any? Please provide some direction on where these can or should be located.	SEI	Refer to RFI #2 response.
6	8-Jan-19	BRG Corporation	Doors schedule A1230 door #s 115-2, 120-1, 120C-1, 120C-2, ST02-2, ST03-3, and ST04-3. Are these doors to be rated?	SEI	The complete door and frame assembly needs to meet the fire rating requirement as noted in the door schedule, refer to sheet A1230 for the door schedule.
7	9-Jan-19	Manning Squires Hennig Co. Inc	Per spec section 12 24 13-Roller Window Shades, there isn't a specific light-filtering and light-blocking fabric specified. Please advise	SEI	Refer to addendum #2, item 2-12 for revisions to the roller window shades specification.
8	9-Jan-19	Manning Squires Hennig Co. Inc	Per section 011000 1.9 & 1.10 contract #1 needs to include portable all toilets and dumpsters for all other contracts. Can an allowance be established into contract #1 for the general contractor to provide these items?	LeChase	No
9	9-Jan-19	Manning Squires Hennig Co. Inc	Per section 015000 4.6 contract #1 shall provide temporary heat during construction operations. Please provide the anticipated duration of when temporary heating will be required within the addition and renovated portions of the building. What is the anticipated date of when new mechanical systems will be turned over to the owner? Can an allowance be established into contract #1 for this item?	LeChase	Anticipated duration of temporary heating will be Oct 4th 2019 thru May 1st 2020. New mechanical systems will be turned over to the owner at Substantial Completion.
10	9-Jan-19	Manning Squires Hennig Co. Inc	Section 004383 does not detail any milestones when or dates for critical path items. Please provide anticipated milestones for the following: 1. Removal of existing Area A 2. Enclosure of new Area A	LeChase	Please refer to Specification Section 01 32 16A
11	9-Jan-19	Concord	Good morning, what is your electrical budget for this including alternates?	LeChase	Base bid, without Alternates, EC budget is \$2.7 mil.
12	9-Jan-19	Tint Shop	I hope your having a great day. I am reaching out because we would love to be part of this project. I noticed a few windows were notated for decorative film but I did not see where the privacy and security film was indicated on the window schedule. If you could clarify for me so I can provide a proper quote I would appreciate it. Thank you.	SEI	Refer to RFI #2 response.
13	9-Jan-19	Manning Squires Hennig Co. Inc	Per foundation note 3 top of the wall shall match the top of the slab. On S2001 at column line A4 top of the wall is indicated to be -4'6". This does not match the top of slab elevation at that location which is -2'0". Please clarify if this is top of the wall or top of the brick ledge	Popli	Refer to addendum #2, item 2-13 for revisions to the foundation plan.